

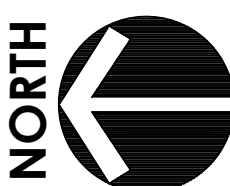


EAST 21ST STREET

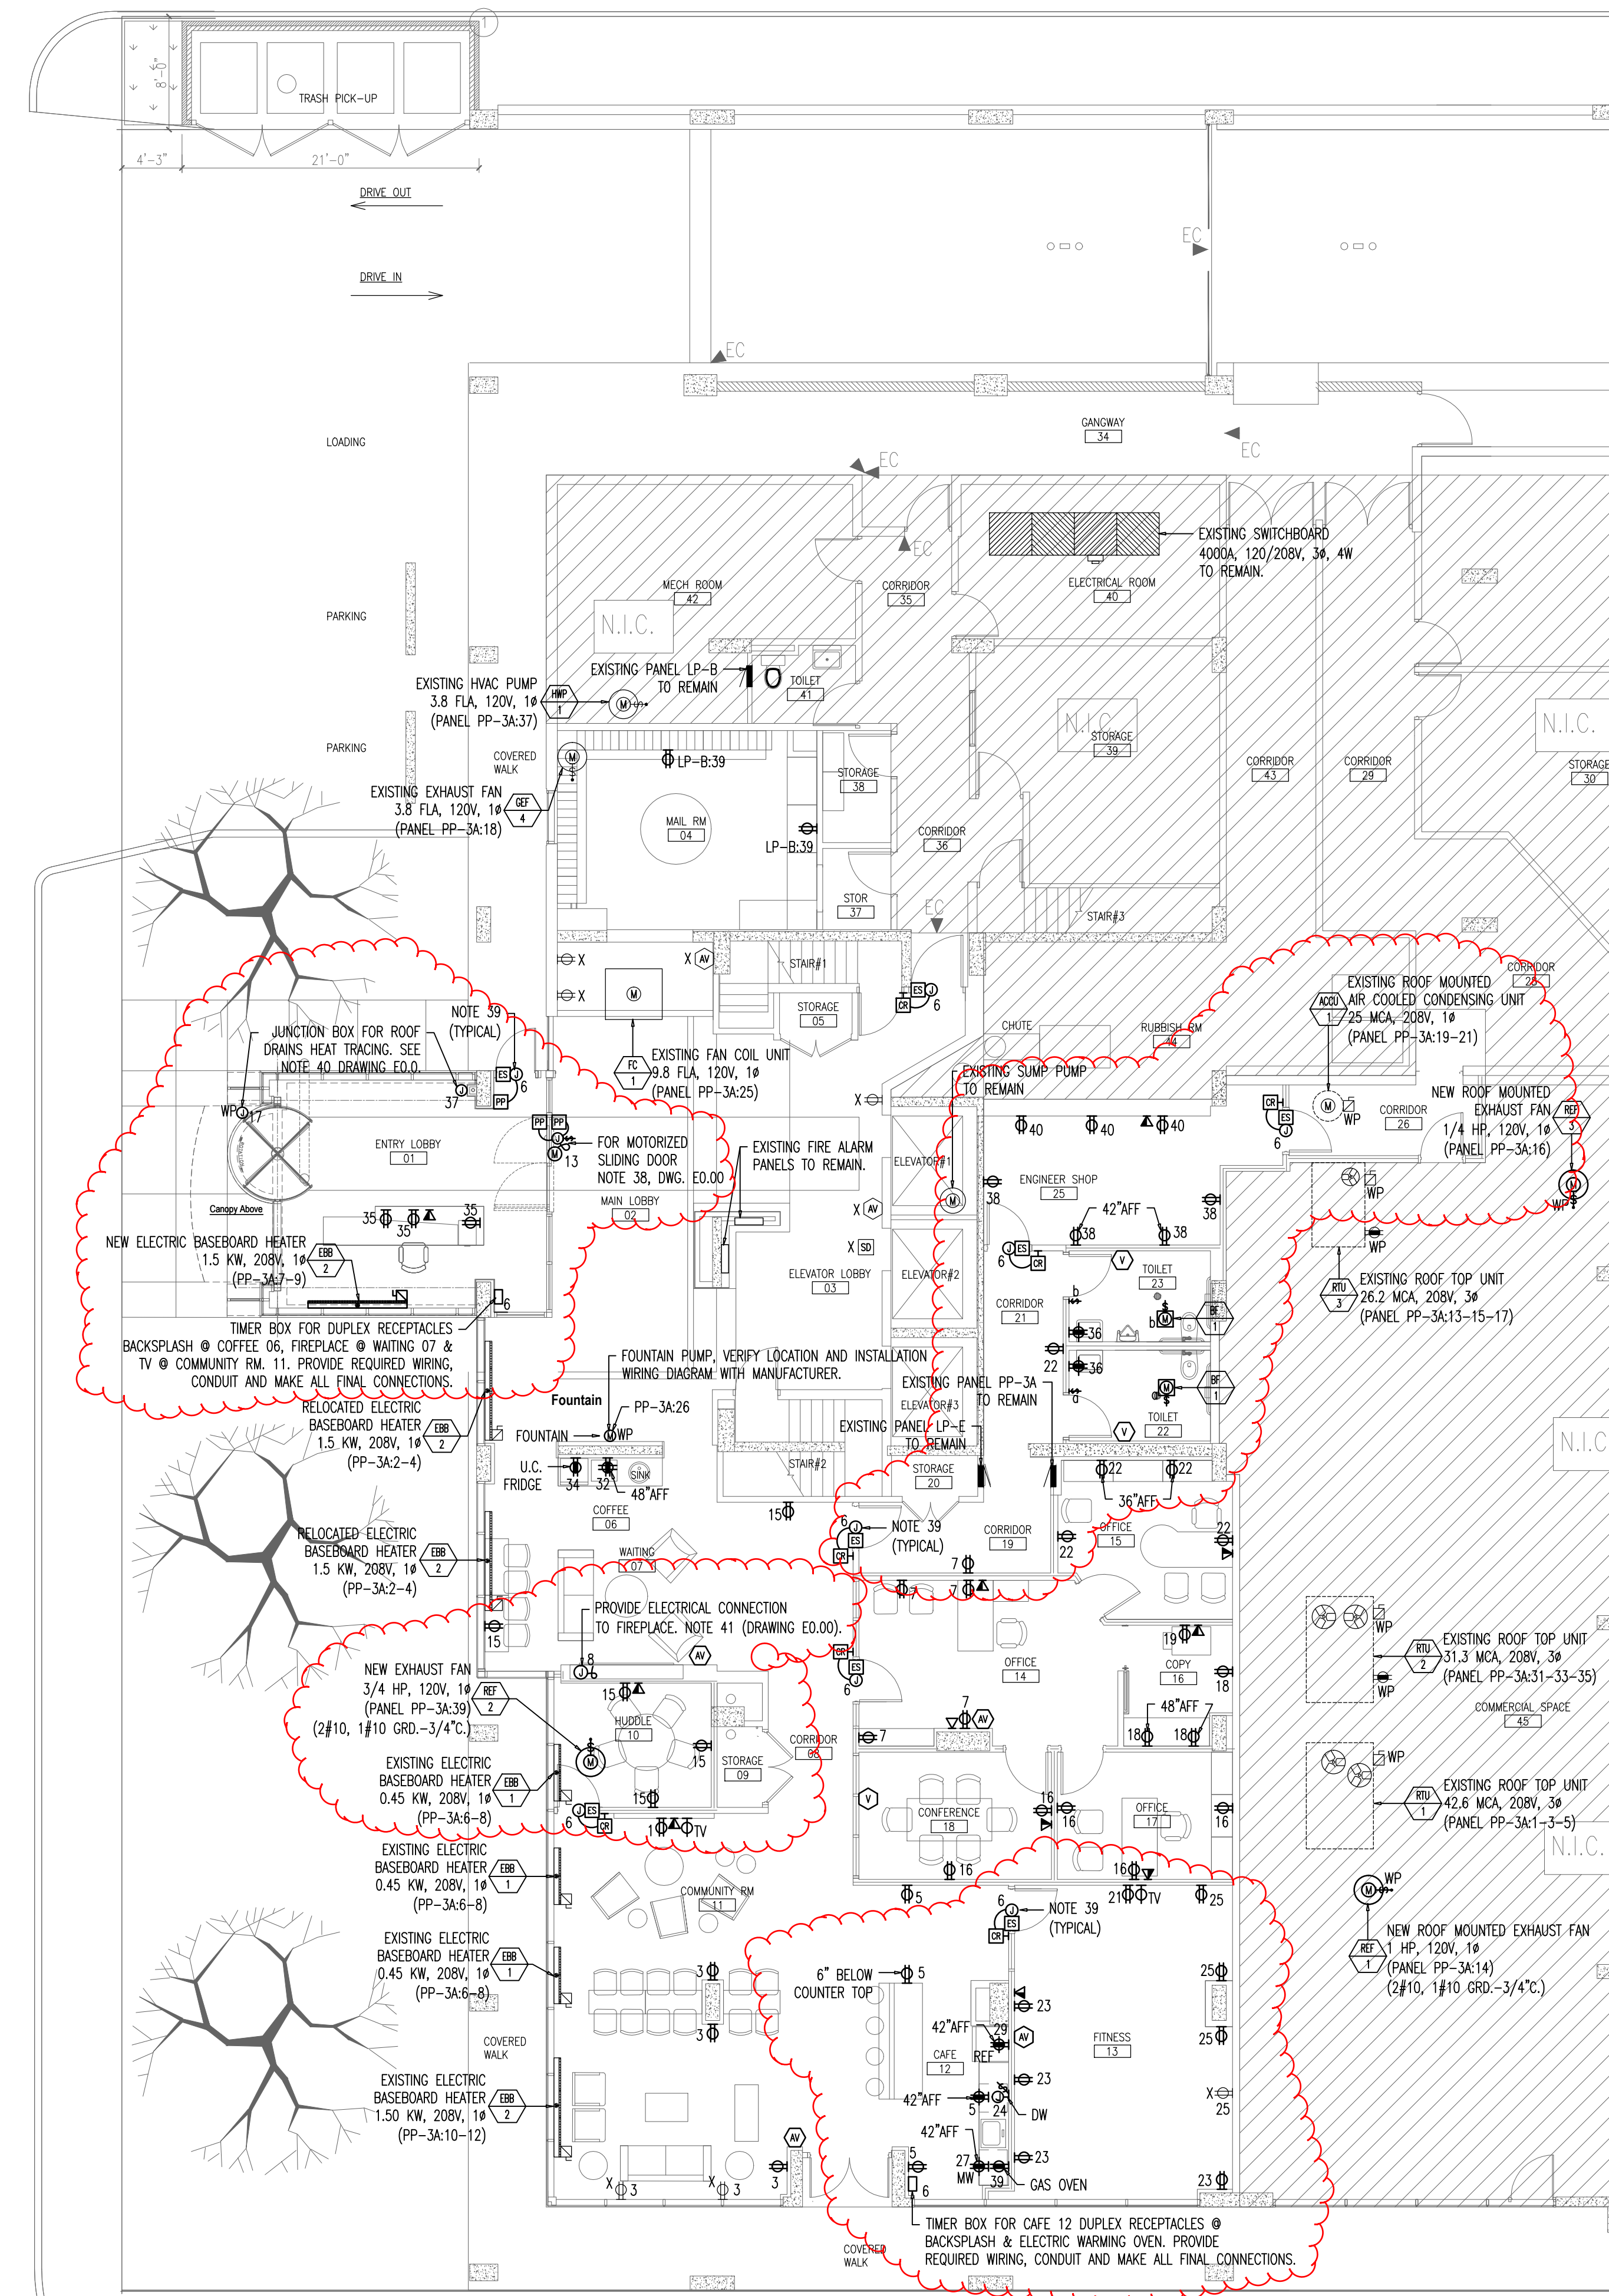


PARTIAL FIRST FLOOR LIGHTING PLAN

SCALE: 1/8" = 1'-0"

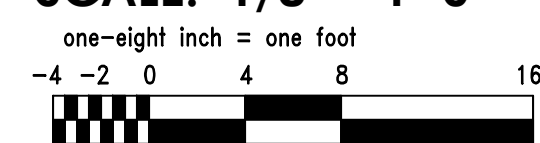


EAST 21ST STREET

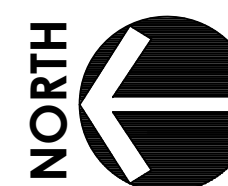

PARTIAL FIRST FLOOR POWER PLAN

SCALE: 1/8" = 1'-0"

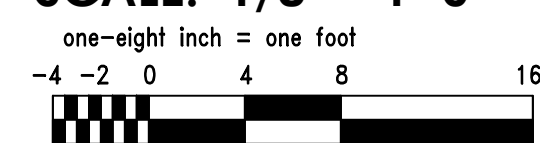

Hereby certify that these plans were prepared under my supervision and that they comply with the best of my knowledge with all the building codes and ordinances of the city of Chicago, IL.

NO.	DATE	DESCRIPTION
1	12.21.17	PROGRESS SET
2	03.30.18	PERMIT SET

A. WILLIAM SEEGRS ARCHITECTS
 Chicago, Illinois 60661
 117 North Jefferson St., Suite LL3B
 Phone 312-454-0099 E-mail AWSee@gsa@aol.com

1st Floor Upgrade Repairs
 2101 S. Michigan Avenue
 Chicago, IL

PARTIAL FIRST FLOOR ELECTRICAL AND LIGHTING PLANS

JOB NO. 1701
 DRAWN BY: -
 CHECKED BY: -
 DATE: 10-06-17
 SHEET NO.

E1.00

MCA #4731