


PLENUM SLOT DIFFUSERS "TITUS" MODEL
 60-10 10" INLET 2-SLOT 1.5" SLOT WIDTH
 4' LONG 300 CFM EACH TYPICAL OF (4)

PLENUM SLOT DIFFUSERS "TITUS" MODEL
 T80-10 8" INLET 1-SLOT 1.5" SLOT WIDTH
 4' LONG 200 CFM EACH TYPICAL OF (12)



PARTIAL FIRST FLOOR MECHANICAL PLAN-NEW
 Scale: 3/16" = 1'-0"

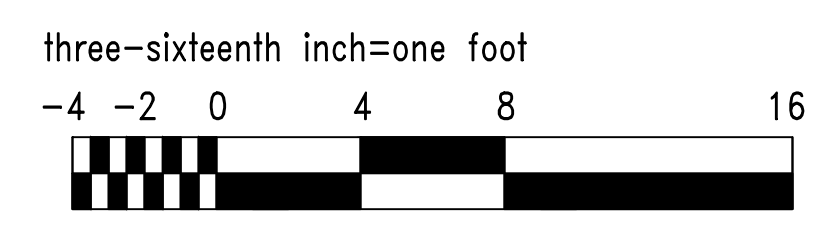

Hereby certify that these plans were prepared under my supervision and that they comply, to the best of my knowledge, with all the building codes and ordinances of the city of Chicago, Ill.

NO.	DATE	DESCRIPTION
1	12.21.17	PROGRESS SET
2	03.30.18	PERMIT SET

A. WILLIAM SEEGERS ARCHITECTS
 Chicago, Illinois 60661
 117 North Jefferson St., Suite LL3B
 Phone 312-454-0099 E-mail AWSeegers@aol.com
 Fax 312-454-1456

Drawing Title:
1st Floor Upgrade Repairs
2101 S. Michigan Avenue
Chicago, IL

DESCRIPTION:
PARTIAL FIRST FLOOR
MECHANICAL PLAN
NEW

JOB NO. 1701
 DRAWN BY: -
 CHECKED BY: -
 DATE: 10-06-17
 SHEET NO.

M1.00

MCA #4731