




- SYMBOL DESIGNATION**
- PROPOSED PARTITION
 - PROPOSED MECHANICAL PICKUP
 - TRACK LIGHT
 - 2" x 2" CEILING DIFFUSER
 - 1" x 1" AIR DIFFUSER
 - LINEAR DIFFUSER
 - SPRINKLER HEAD
 - EXIT SIGN

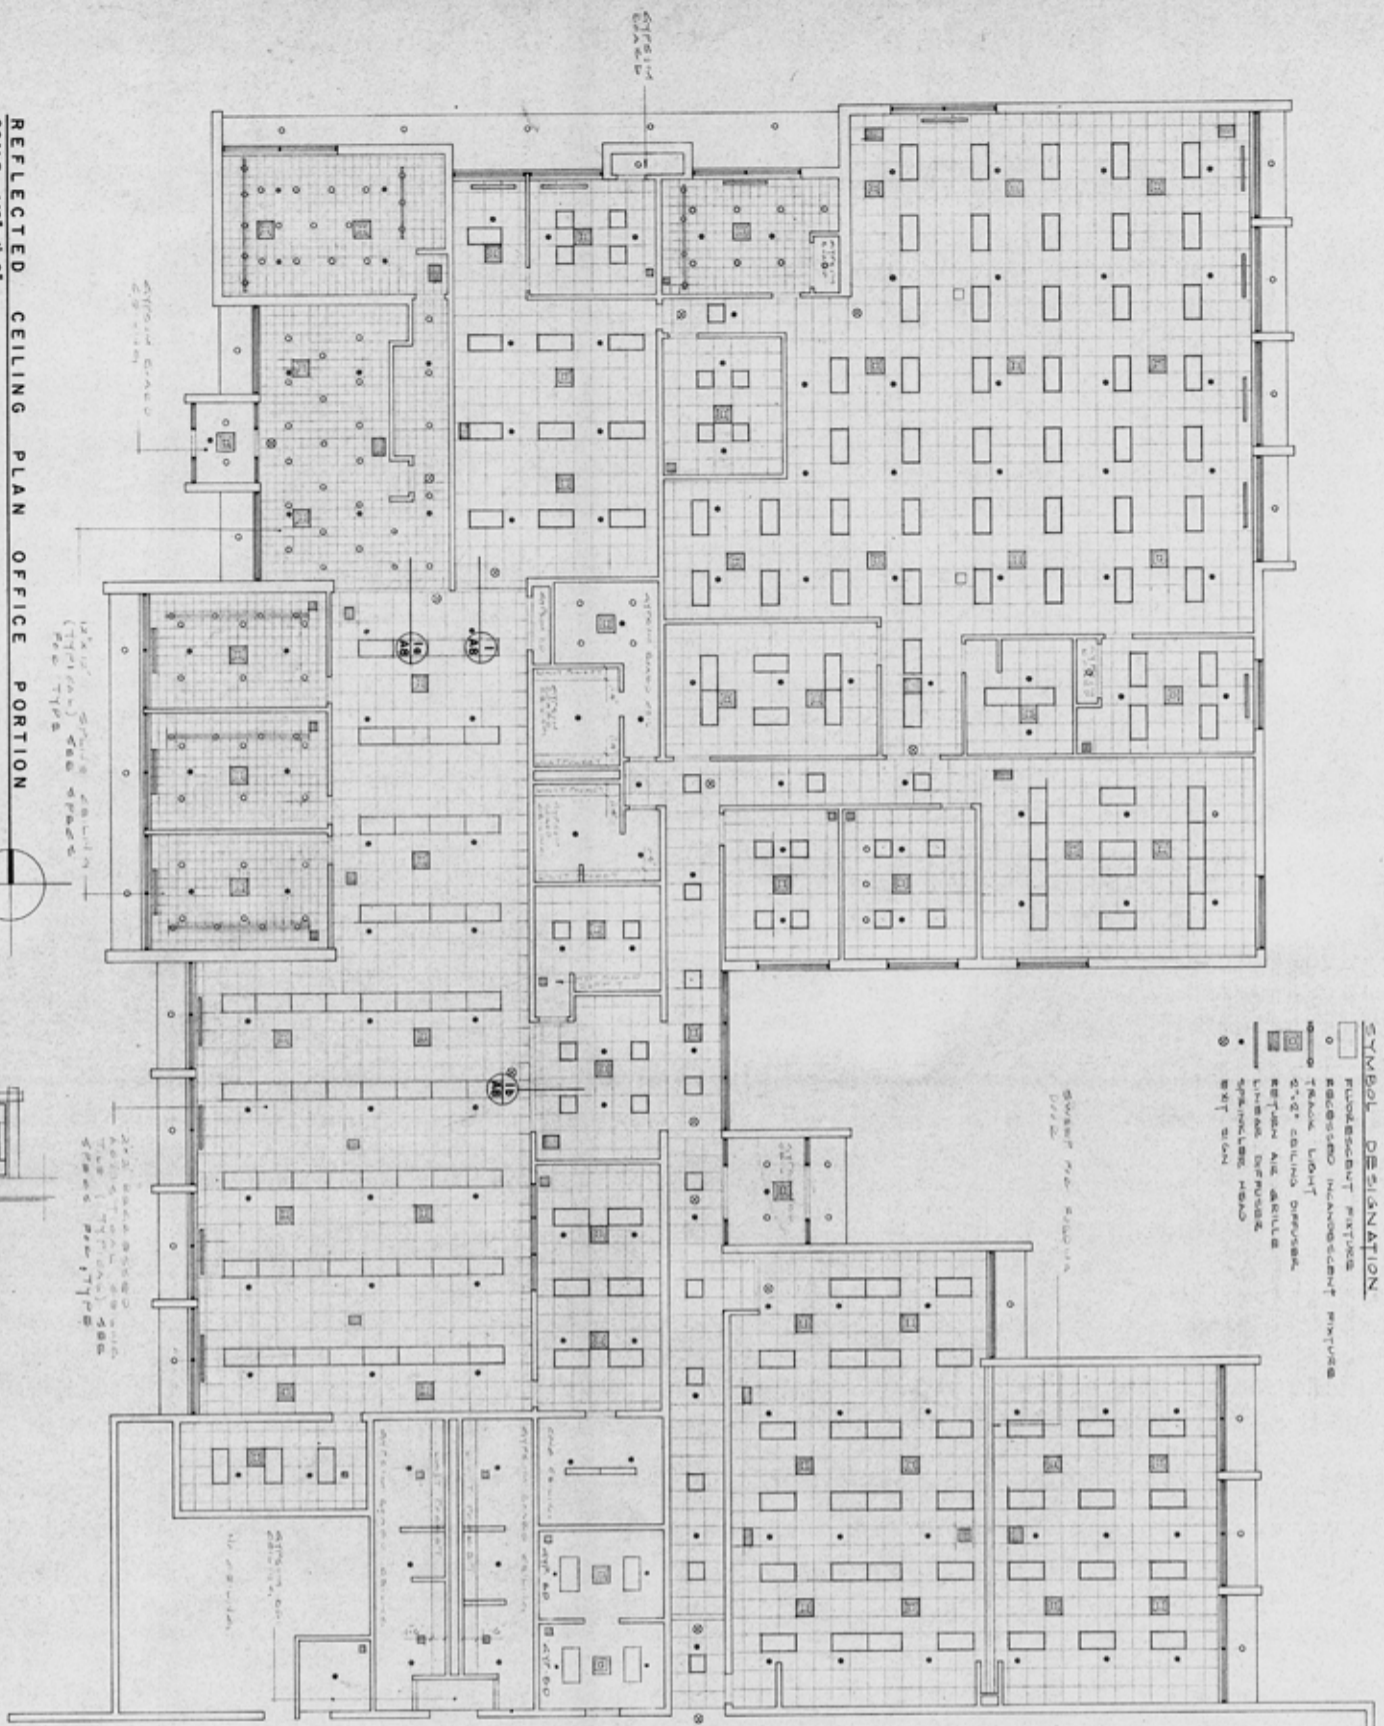


REFLECTED CEILING PLAN OFFICE PORTION
SCALE 1/8"=1'-0"

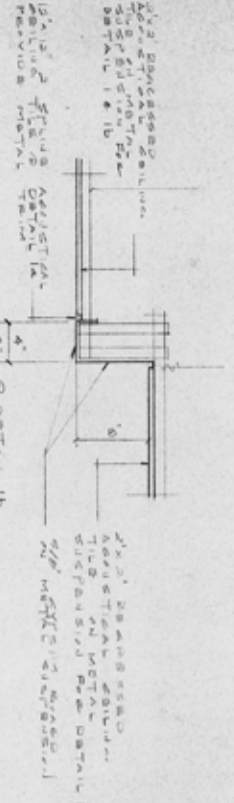













1 1a 1b
SCALE 1/2"=1'-0"

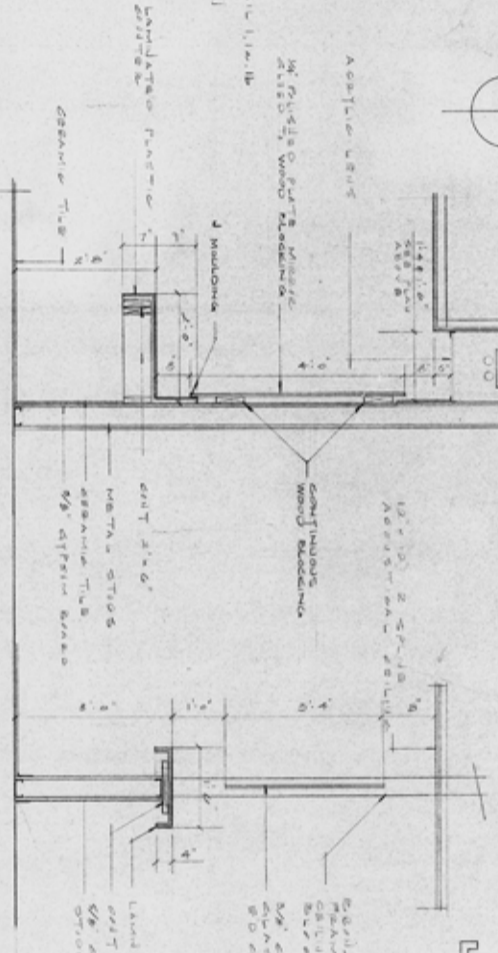

2

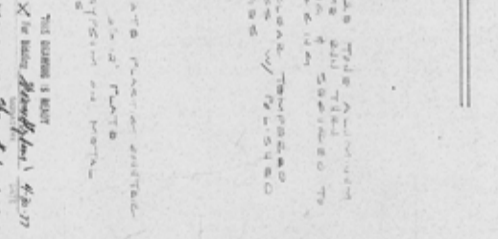

3

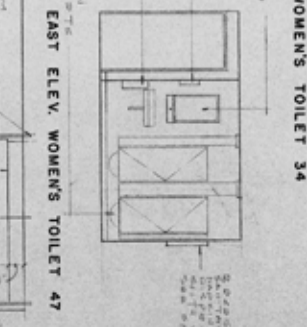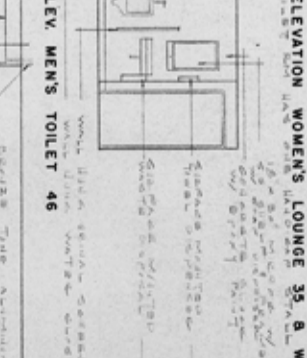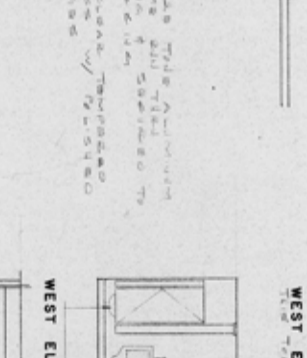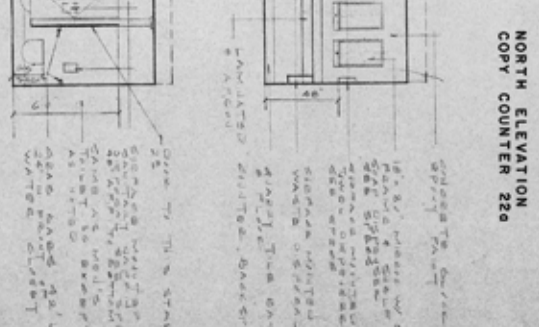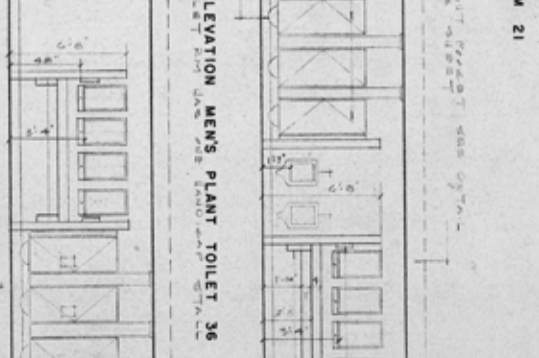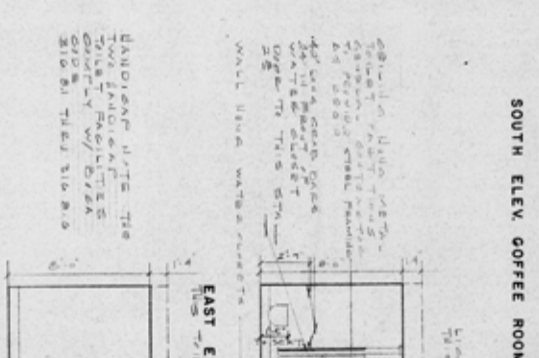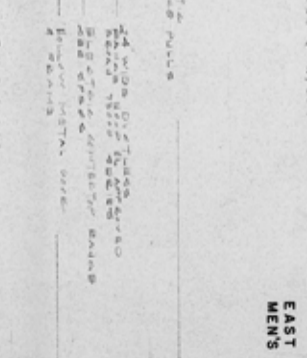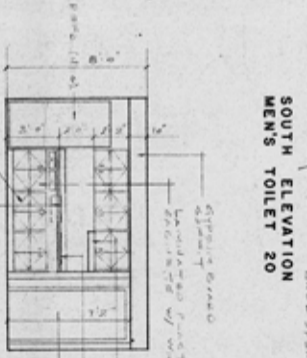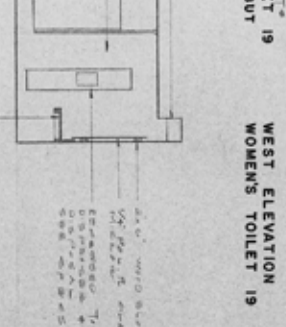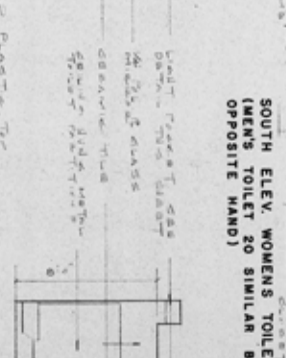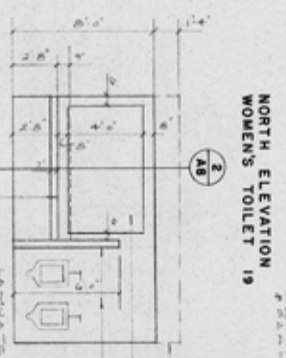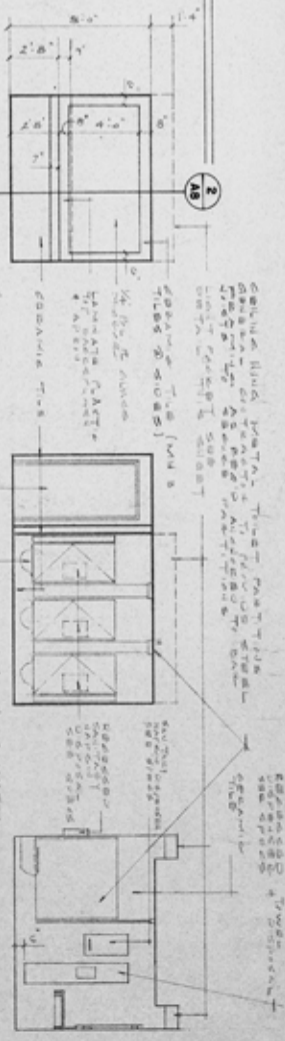

SMITH & STEPHENS ARCHITECTS, INC.
LOVE CONTROLS CORPORATION
S. E. COR. OF HOLBROOK DR. & WHEELING RD.
WHEELING, ILLINOIS

REVISION DATE: JUNE 28, 1977
JOB NUMBER: 7726
JOB DATE: APRIL 30, 1977
SHEET NUMBER: A8 OF 8 SHEETS