

INDEX OF DRAWINGS

- ARCHITECTURAL**
- A 1 SITE B ROOF PLAN & DETAILS
- A 2 OFFICE FLOOR PLAN & DETAILS
- A 3 PLANT FLOOR PLAN & DETAILS
- A 4 ELEVATIONS
- A 5 WALL SECTIONS
- A 6 WALL SECTIONS & DETAILS
- A 7 SCHEDULES & DETAILS
- A 8 REFLECTED CEILING PLAN & INT. ELEVATIONS
- STRUCTURAL**
- S 1 OFFICE FOUNDATION PLAN
- S 2 PLANT FOUNDATION PLAN
- S 3 FOUNDATION DETAILS
- S 4 OFFICE ROOF FRAMING PLAN & SCHEDULES
- S 5 PLANT ROOF FRAMING PLAN
- S 6 STRUCTURAL DETAILS
- MECHANICAL**
- U 1 UTILITY SITE PLAN & DETAILS
- M 1 OFFICE H.V.A.C. PLAN
- M 2 PLANT H.V.A.C. PLAN
- M 3 MECHANICAL EQUIPMENT SCHEDULES
- P 1 OFFICE PLUMBING & FIRE PROTECTION PLAN
- P 2 PLANT PLUMBING & FIRE PROTECTION PLAN
- E 1 OFFICE LIGHTING PLAN
- E 2 OFFICE POWER PLAN
- E 3 PLANT LIGHTING PLAN
- E 4 PLANT POWER PLAN
- E 5 ELECTRICAL RISER DIAGRAM

SITE B ROOF PLAN

PARKING REQUIREMENTS PER WHEELING MUNICIPAL CODE


- A. PLANT PARKING
- B. OFFICE PARKING

Existing Site plan


February 12, 2011

A1

NOT TO SCALE

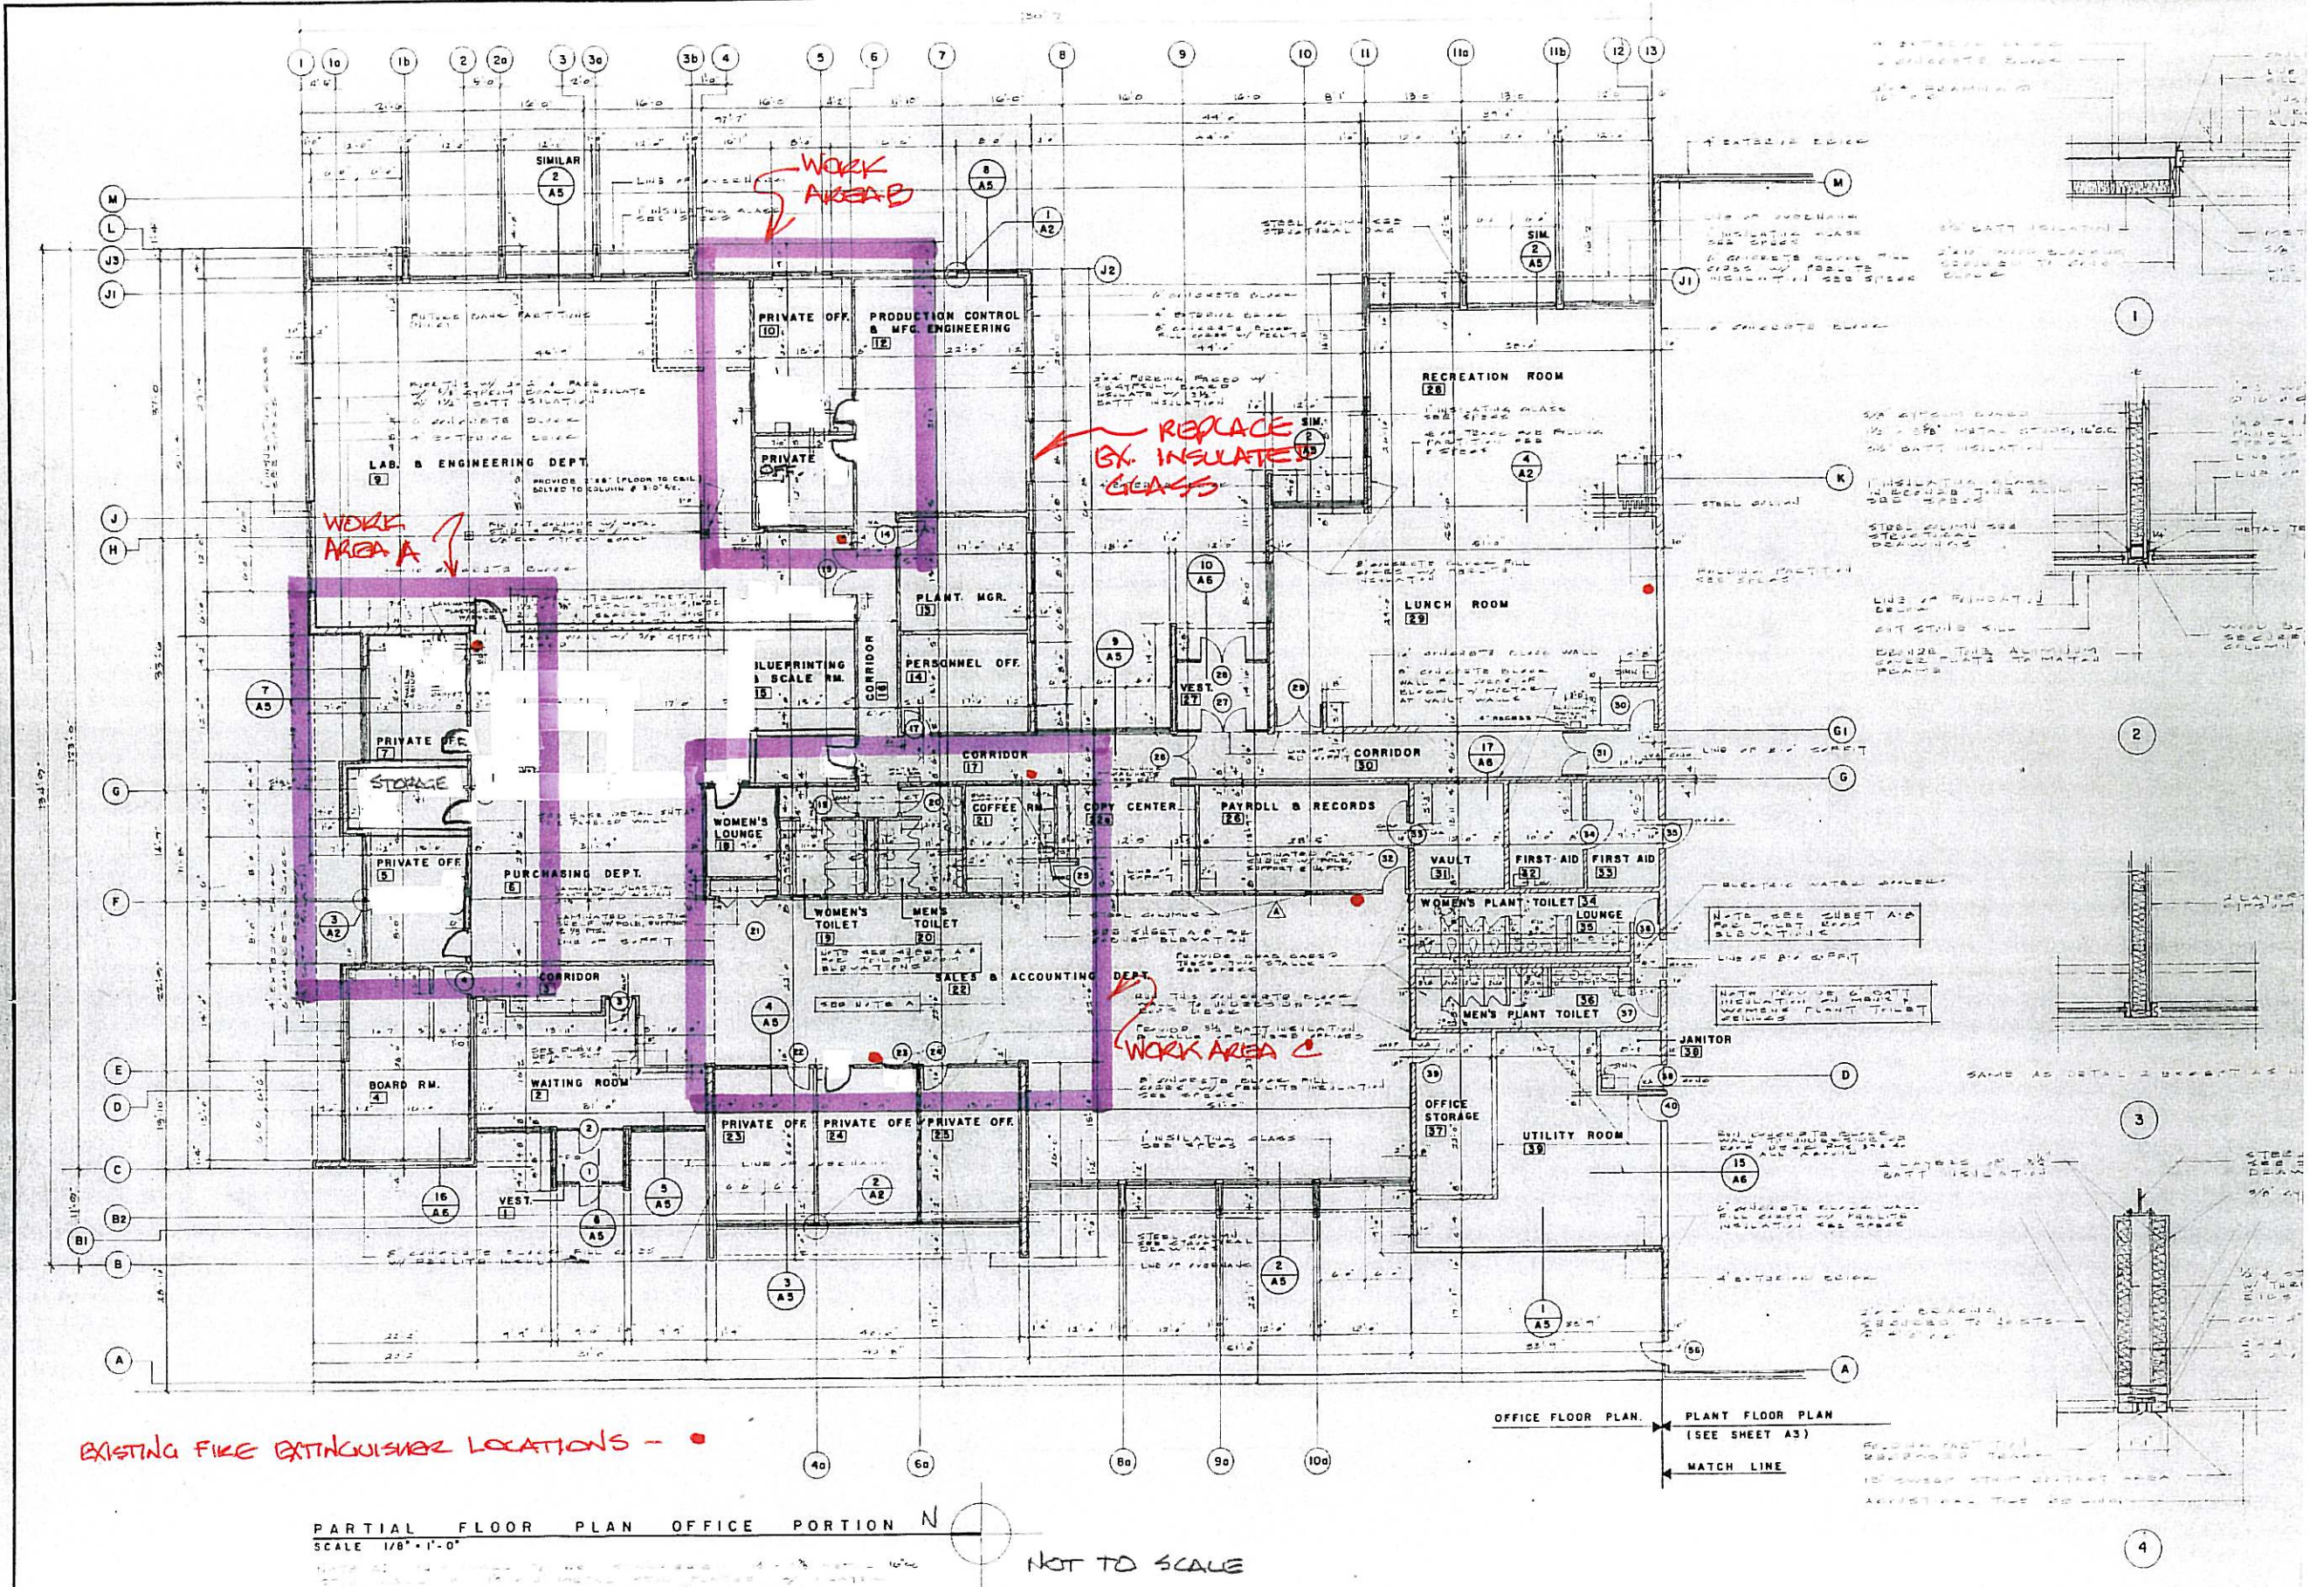


Existing Floor Plan February 12, 2011

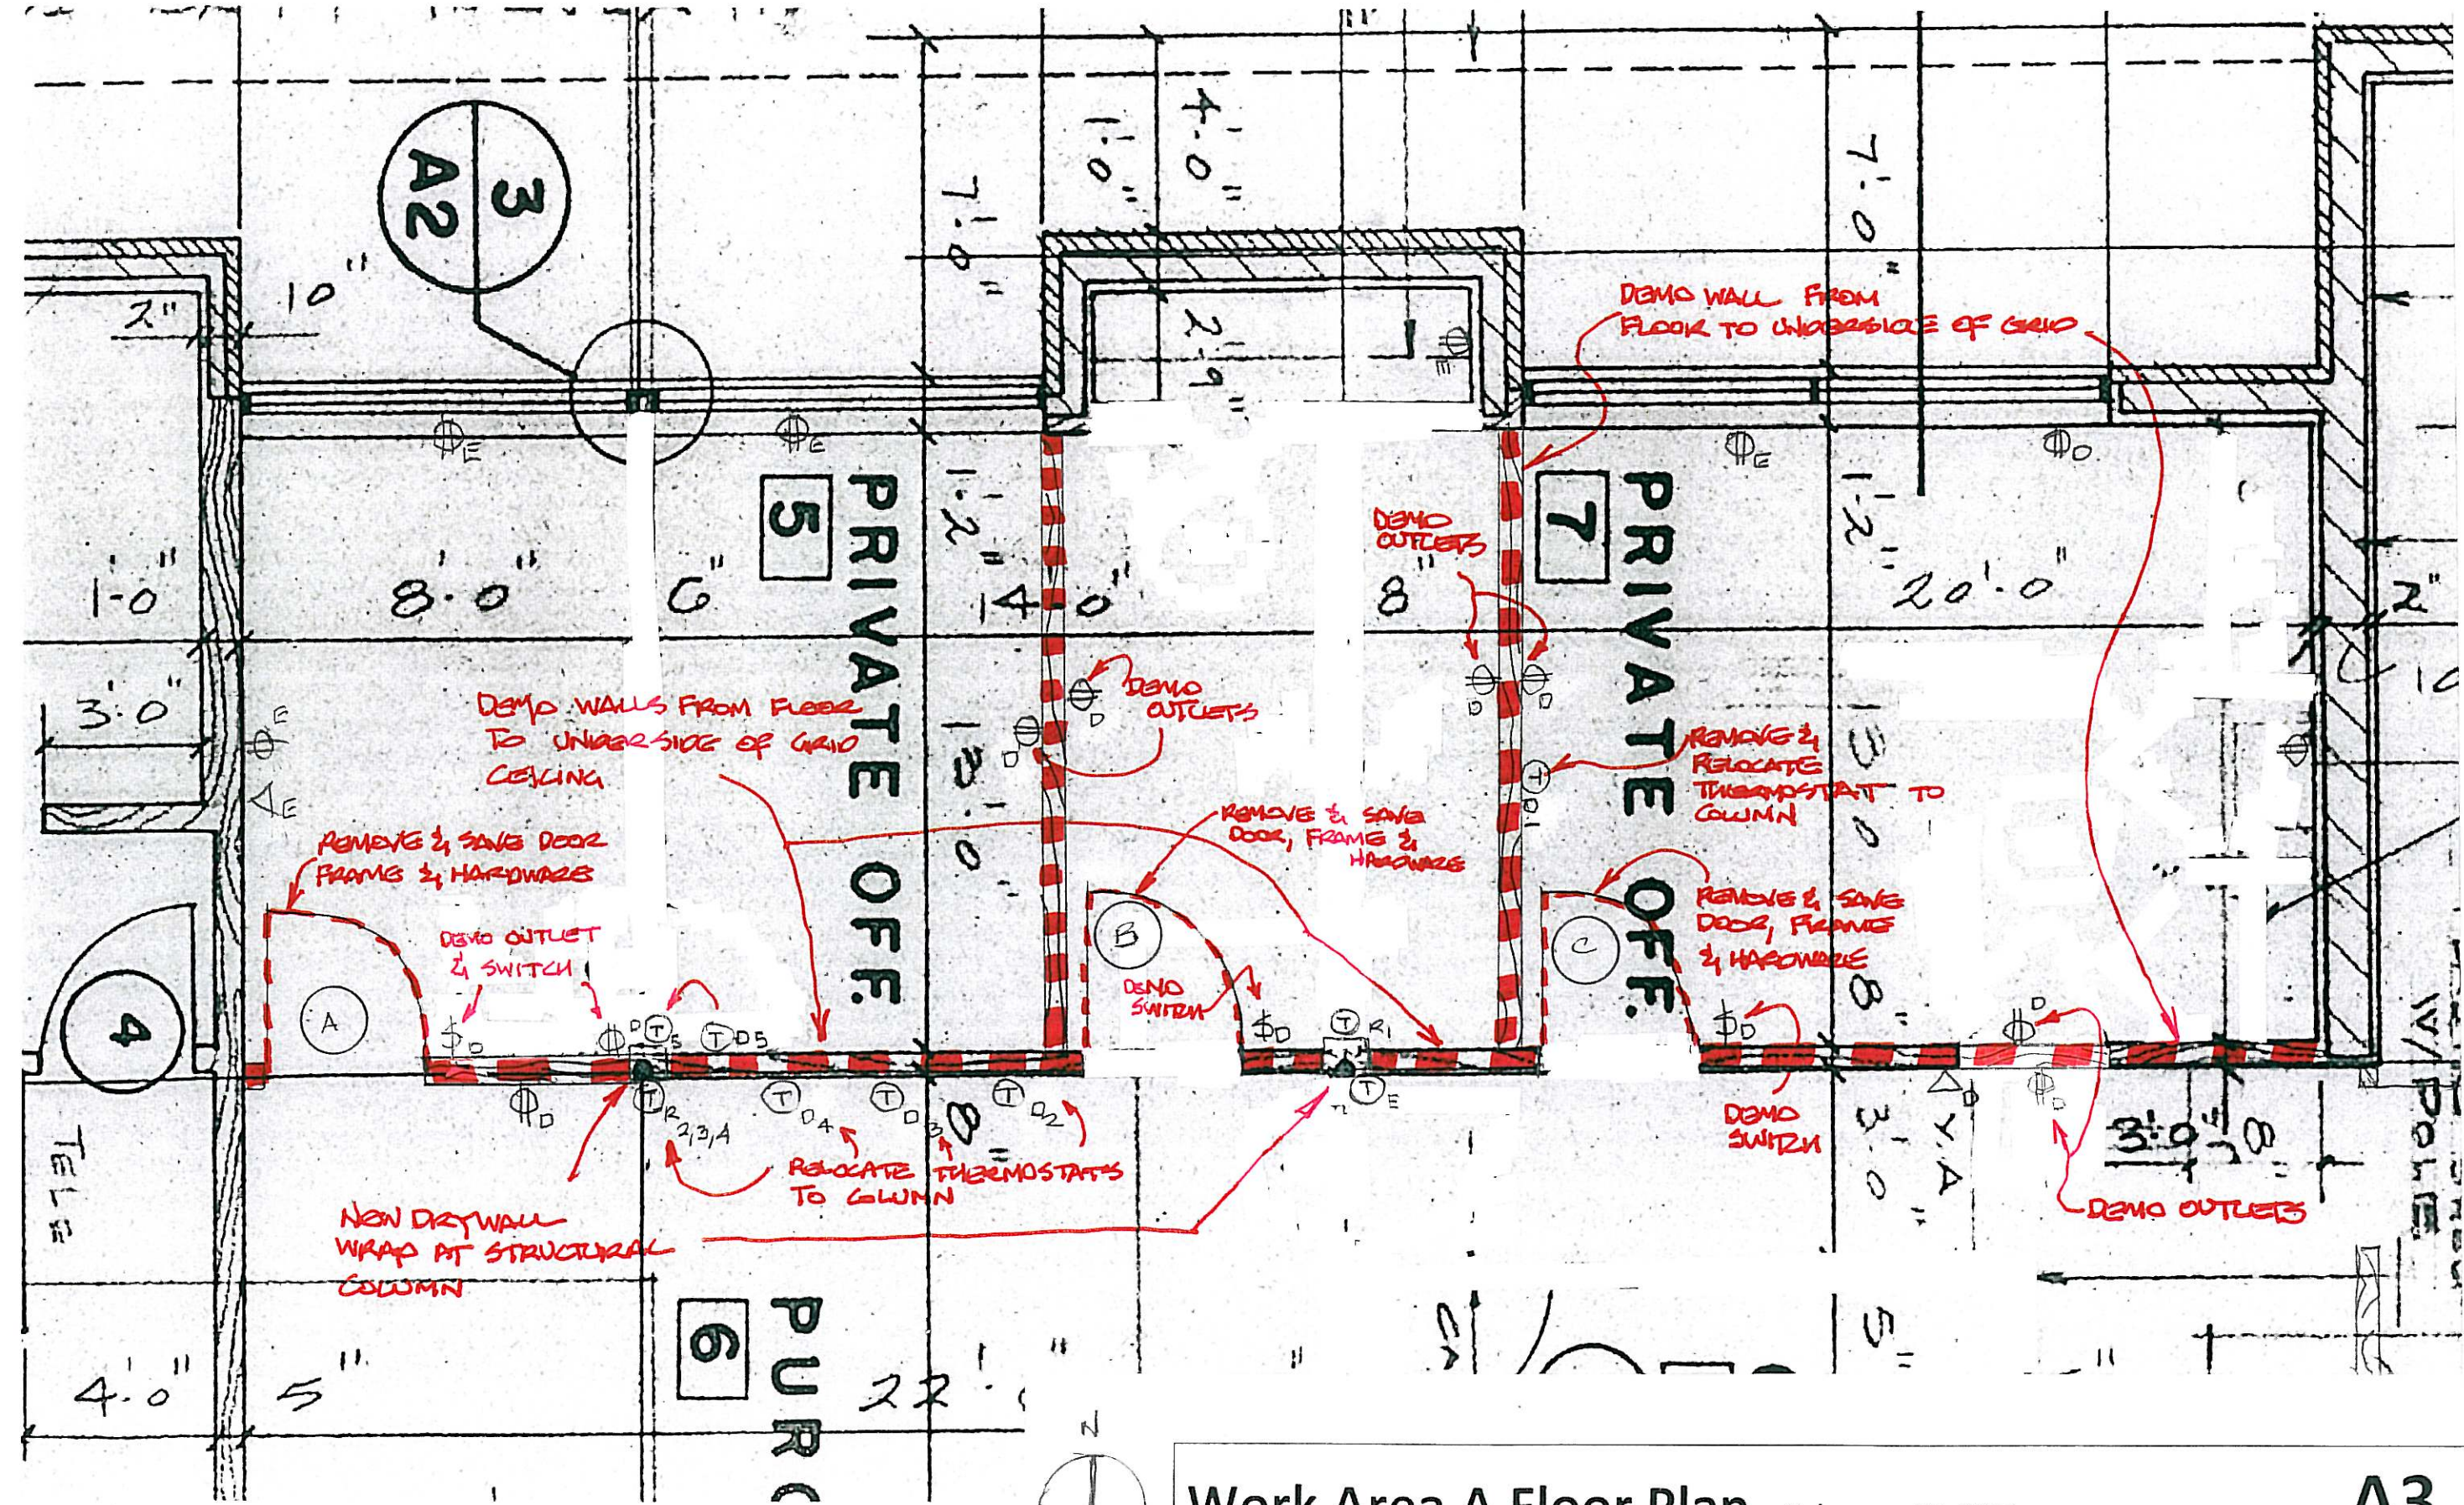

Work Area A Floor Plan February 12, 2011

A3

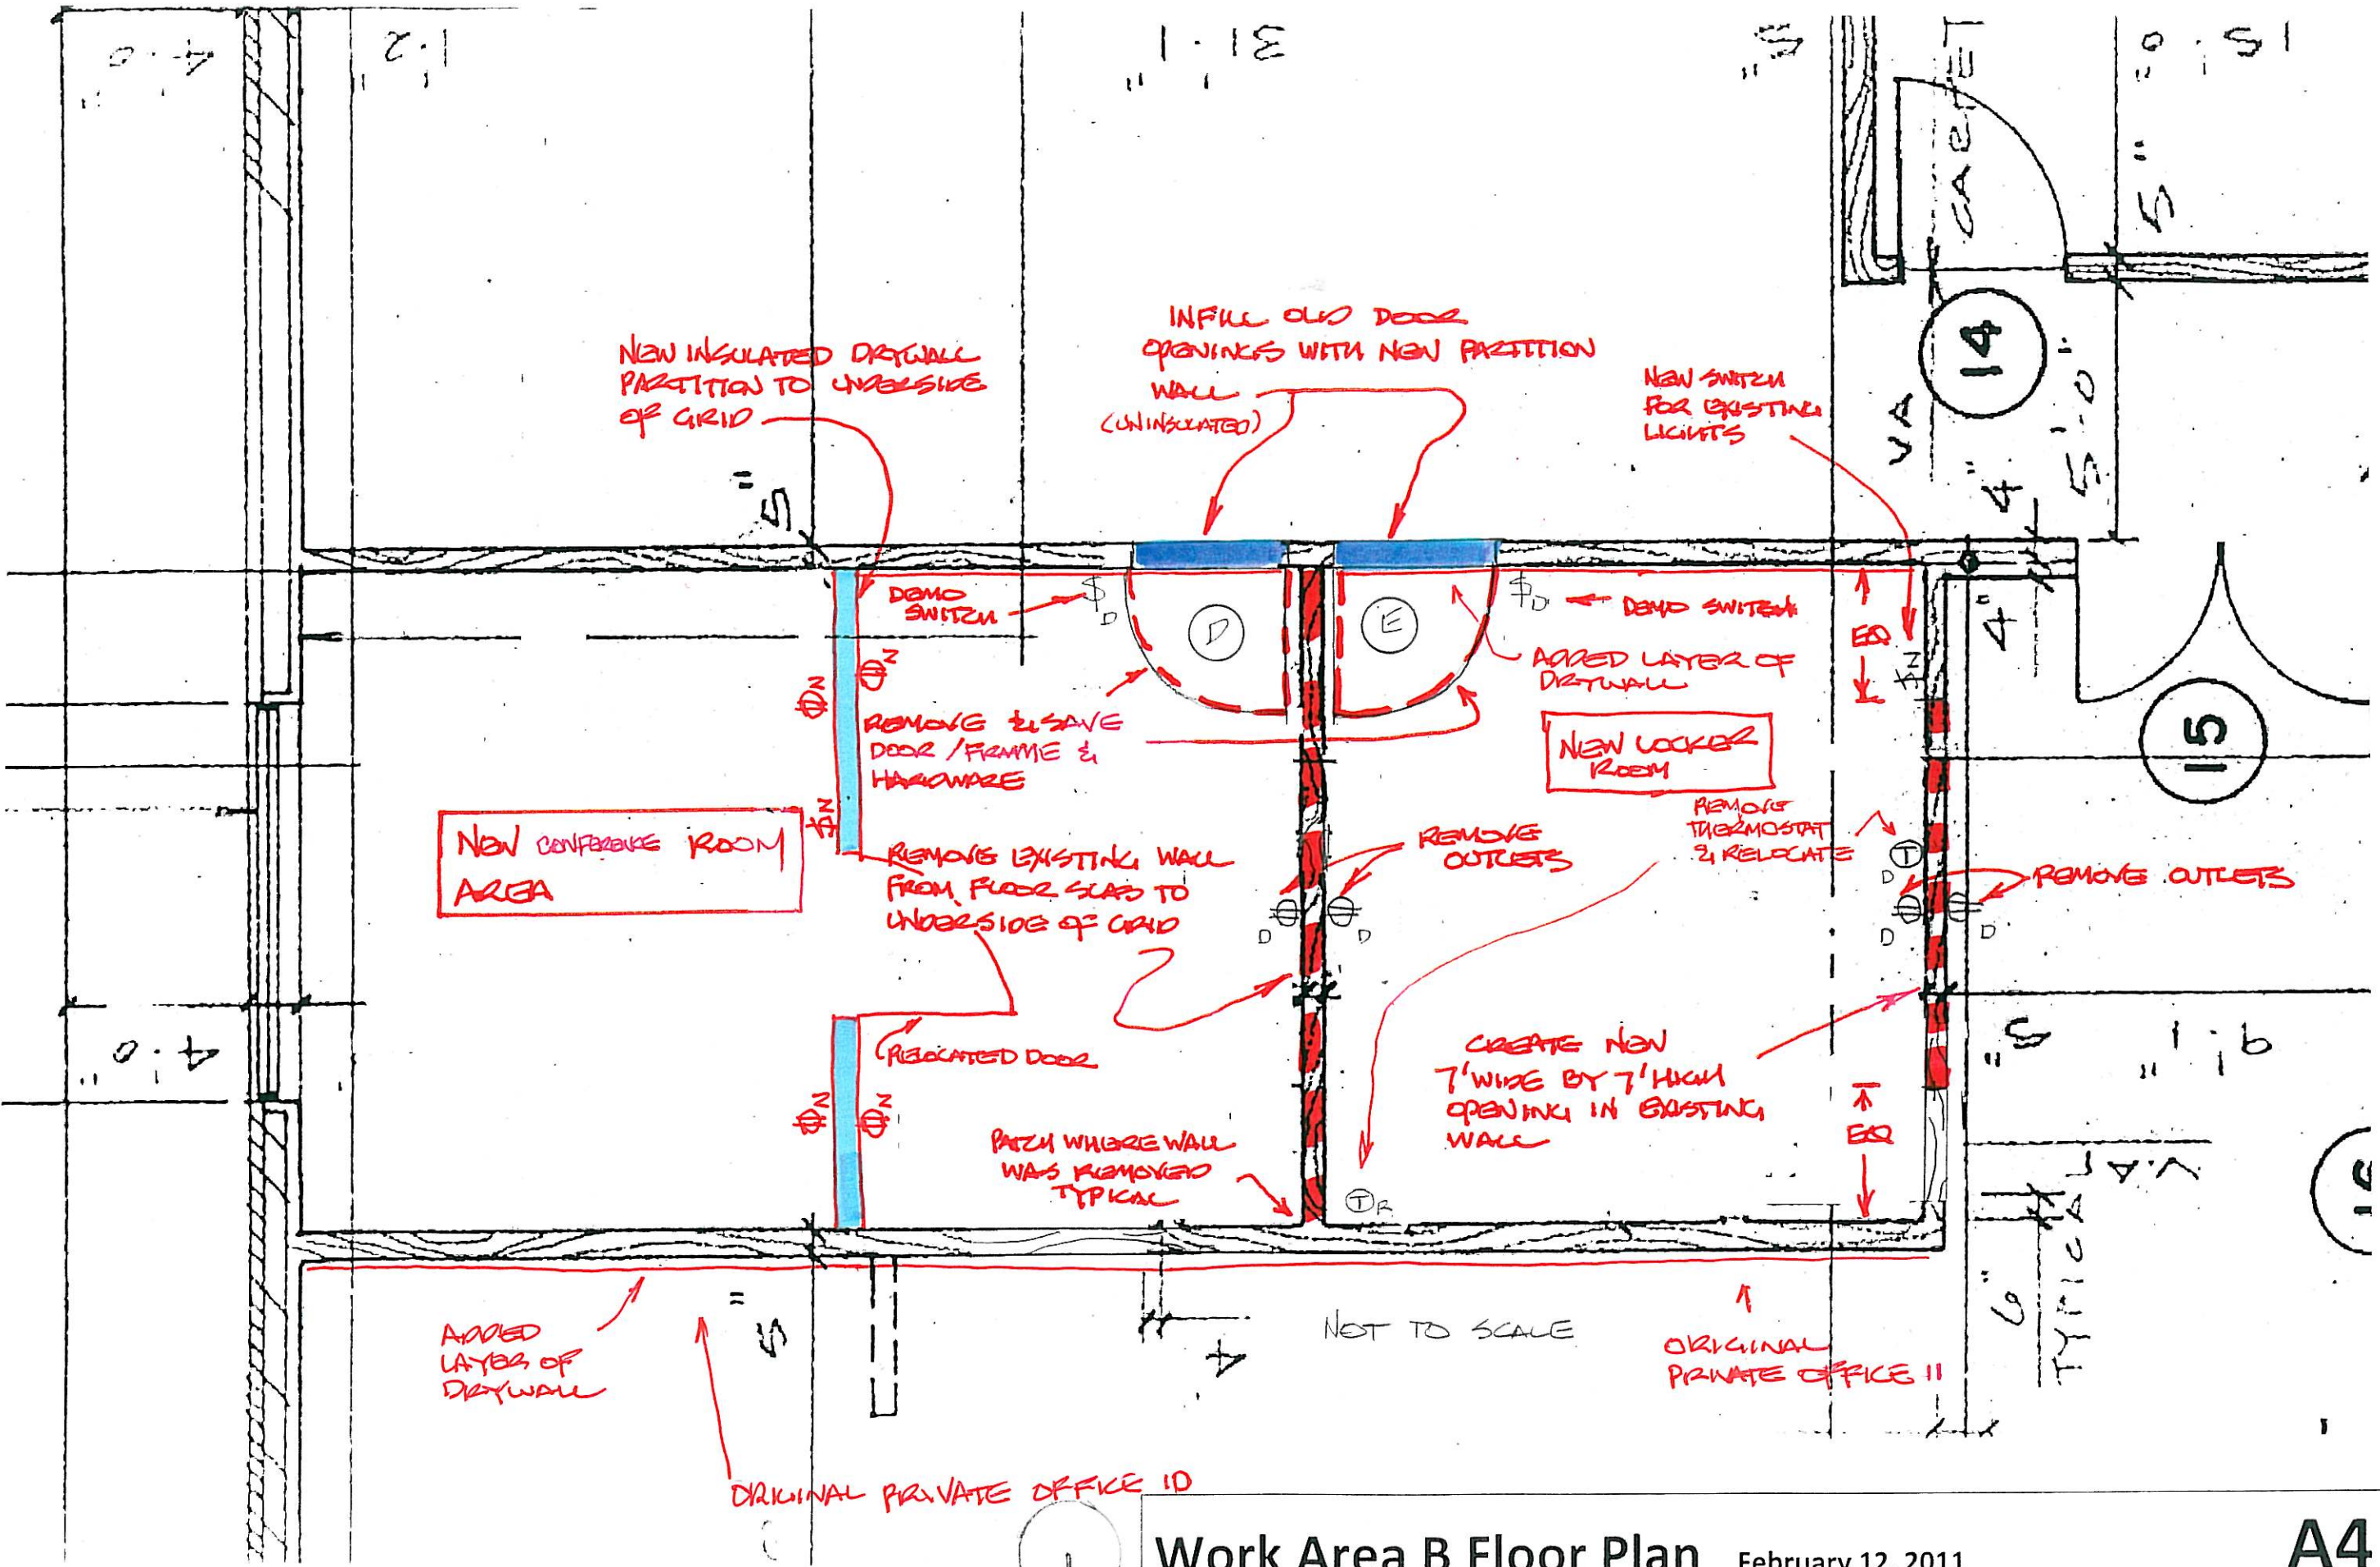


Office and toilet room remodeling work

Creation Technologies – 1475 S. Wheeling Road, Wheeling, IL

Work Area B Floor Plan February 12, 2011

A4

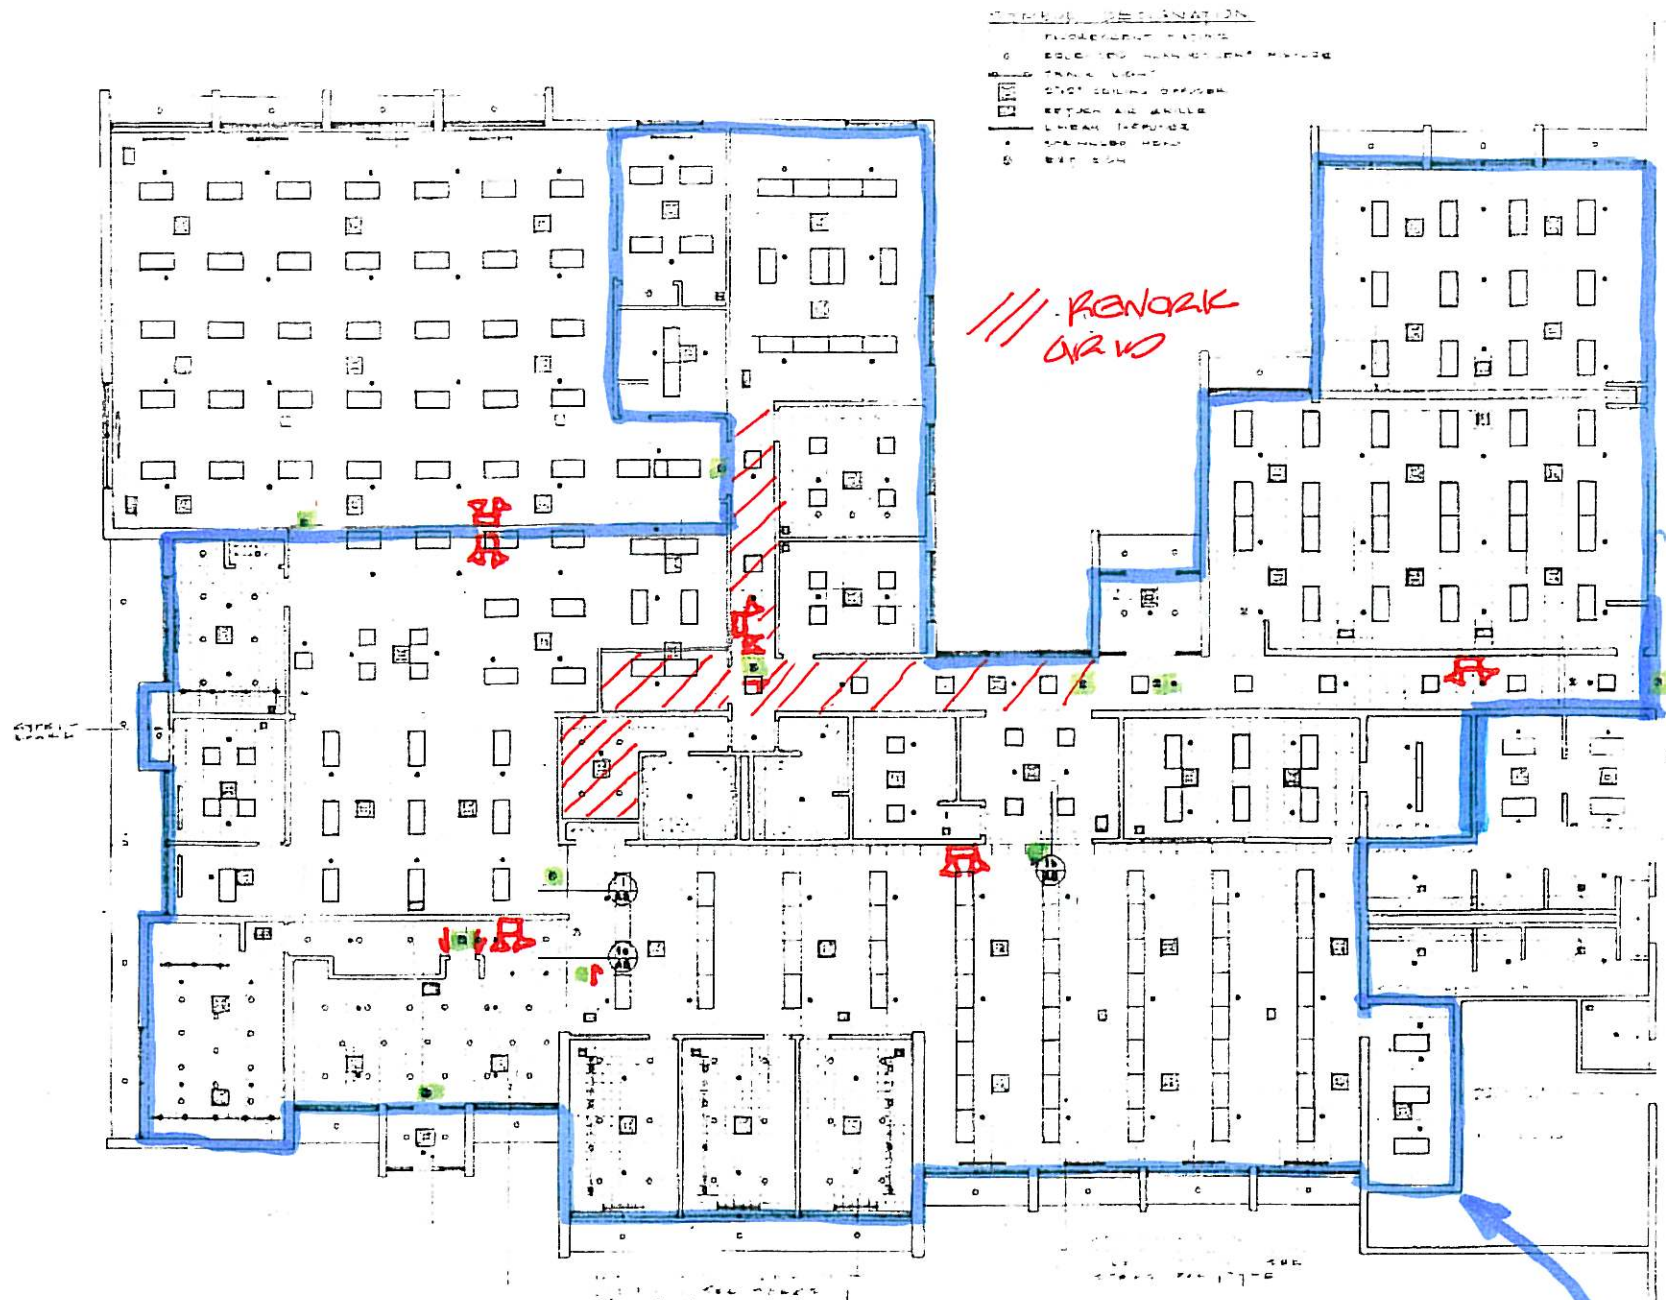


REFLECTED CEILING PLAN OFFICE PORTION
 SCALE 1/8" = 1'-0"

⊗ EXISTING EXIT SIGN LOCATION
 ⚡ EXISTING TWO HEAD BATTERY EMERGENCY LIGHT


NOTE: SEE ENLARGED ARCHITECTURAL DRAWINGS FOR ADDITIONAL / RELOCATED EXITS & EMERGENCY LIGHTING

REWORK OR VO

PROVIDE AN ALTERNATE COST TO REMOVE & REPLACE EXISTING CEILING TILE WITHIN THIS AREA

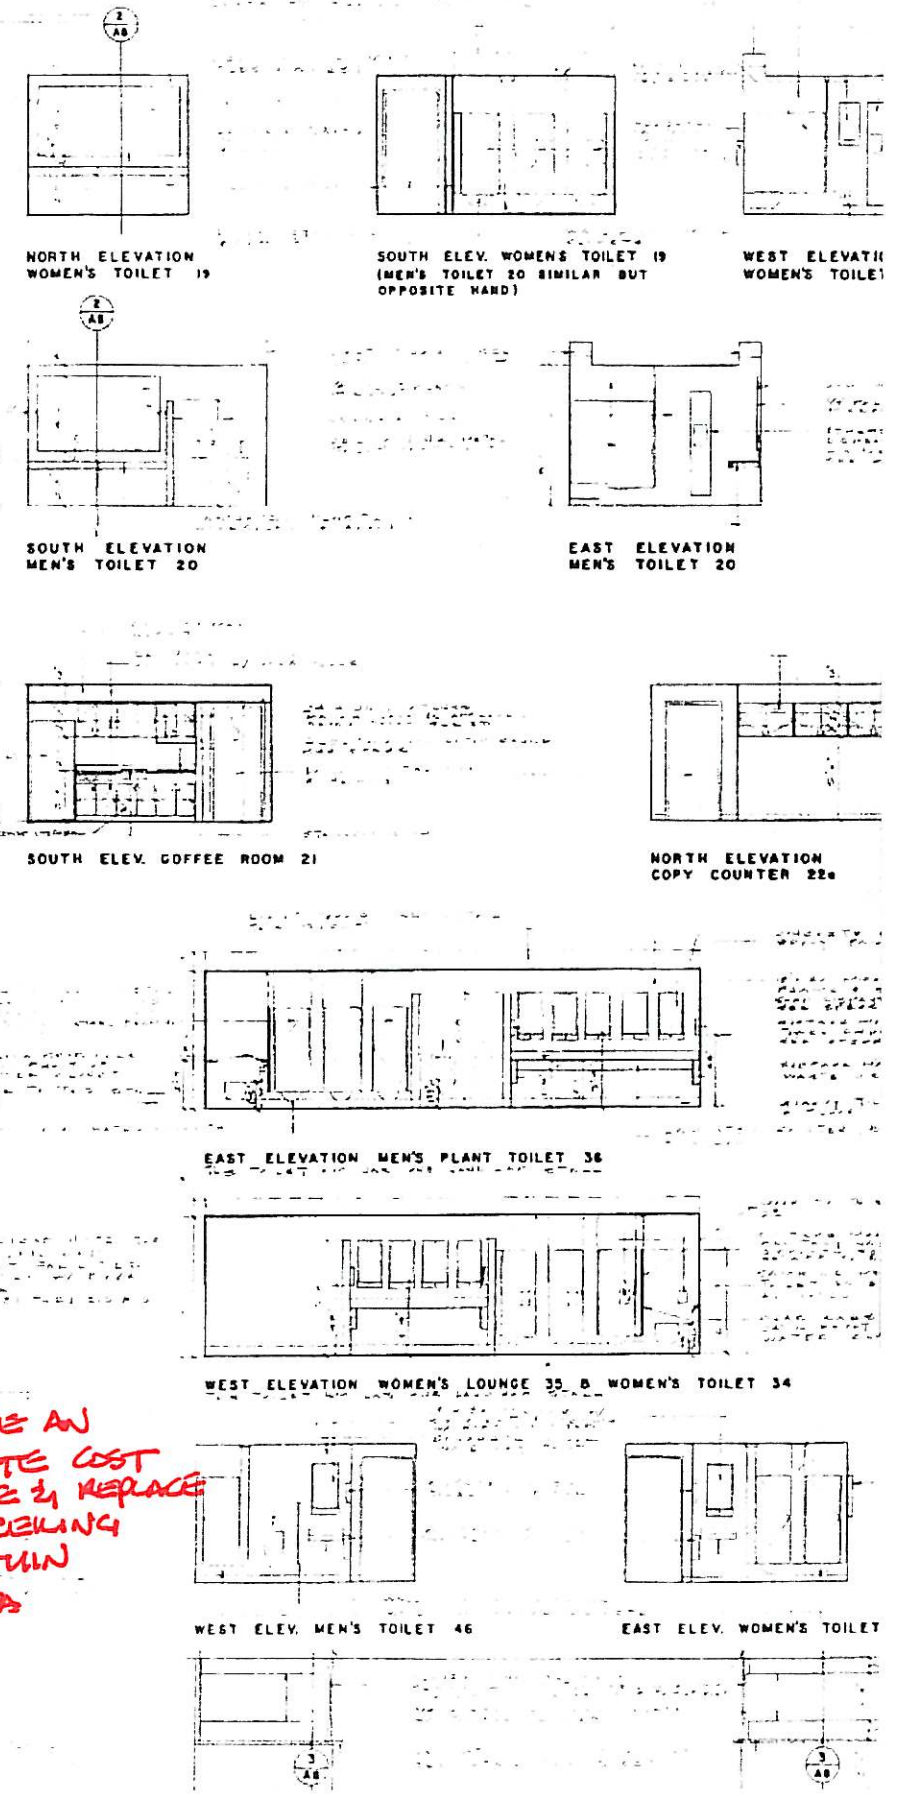


NOTE: FIREPROTECTION
CONTRACTOR TO VERIFY THAT EXISTING
LOCATIONS OF SPRINKLER HEADS SATISFY
PRESENT CODES

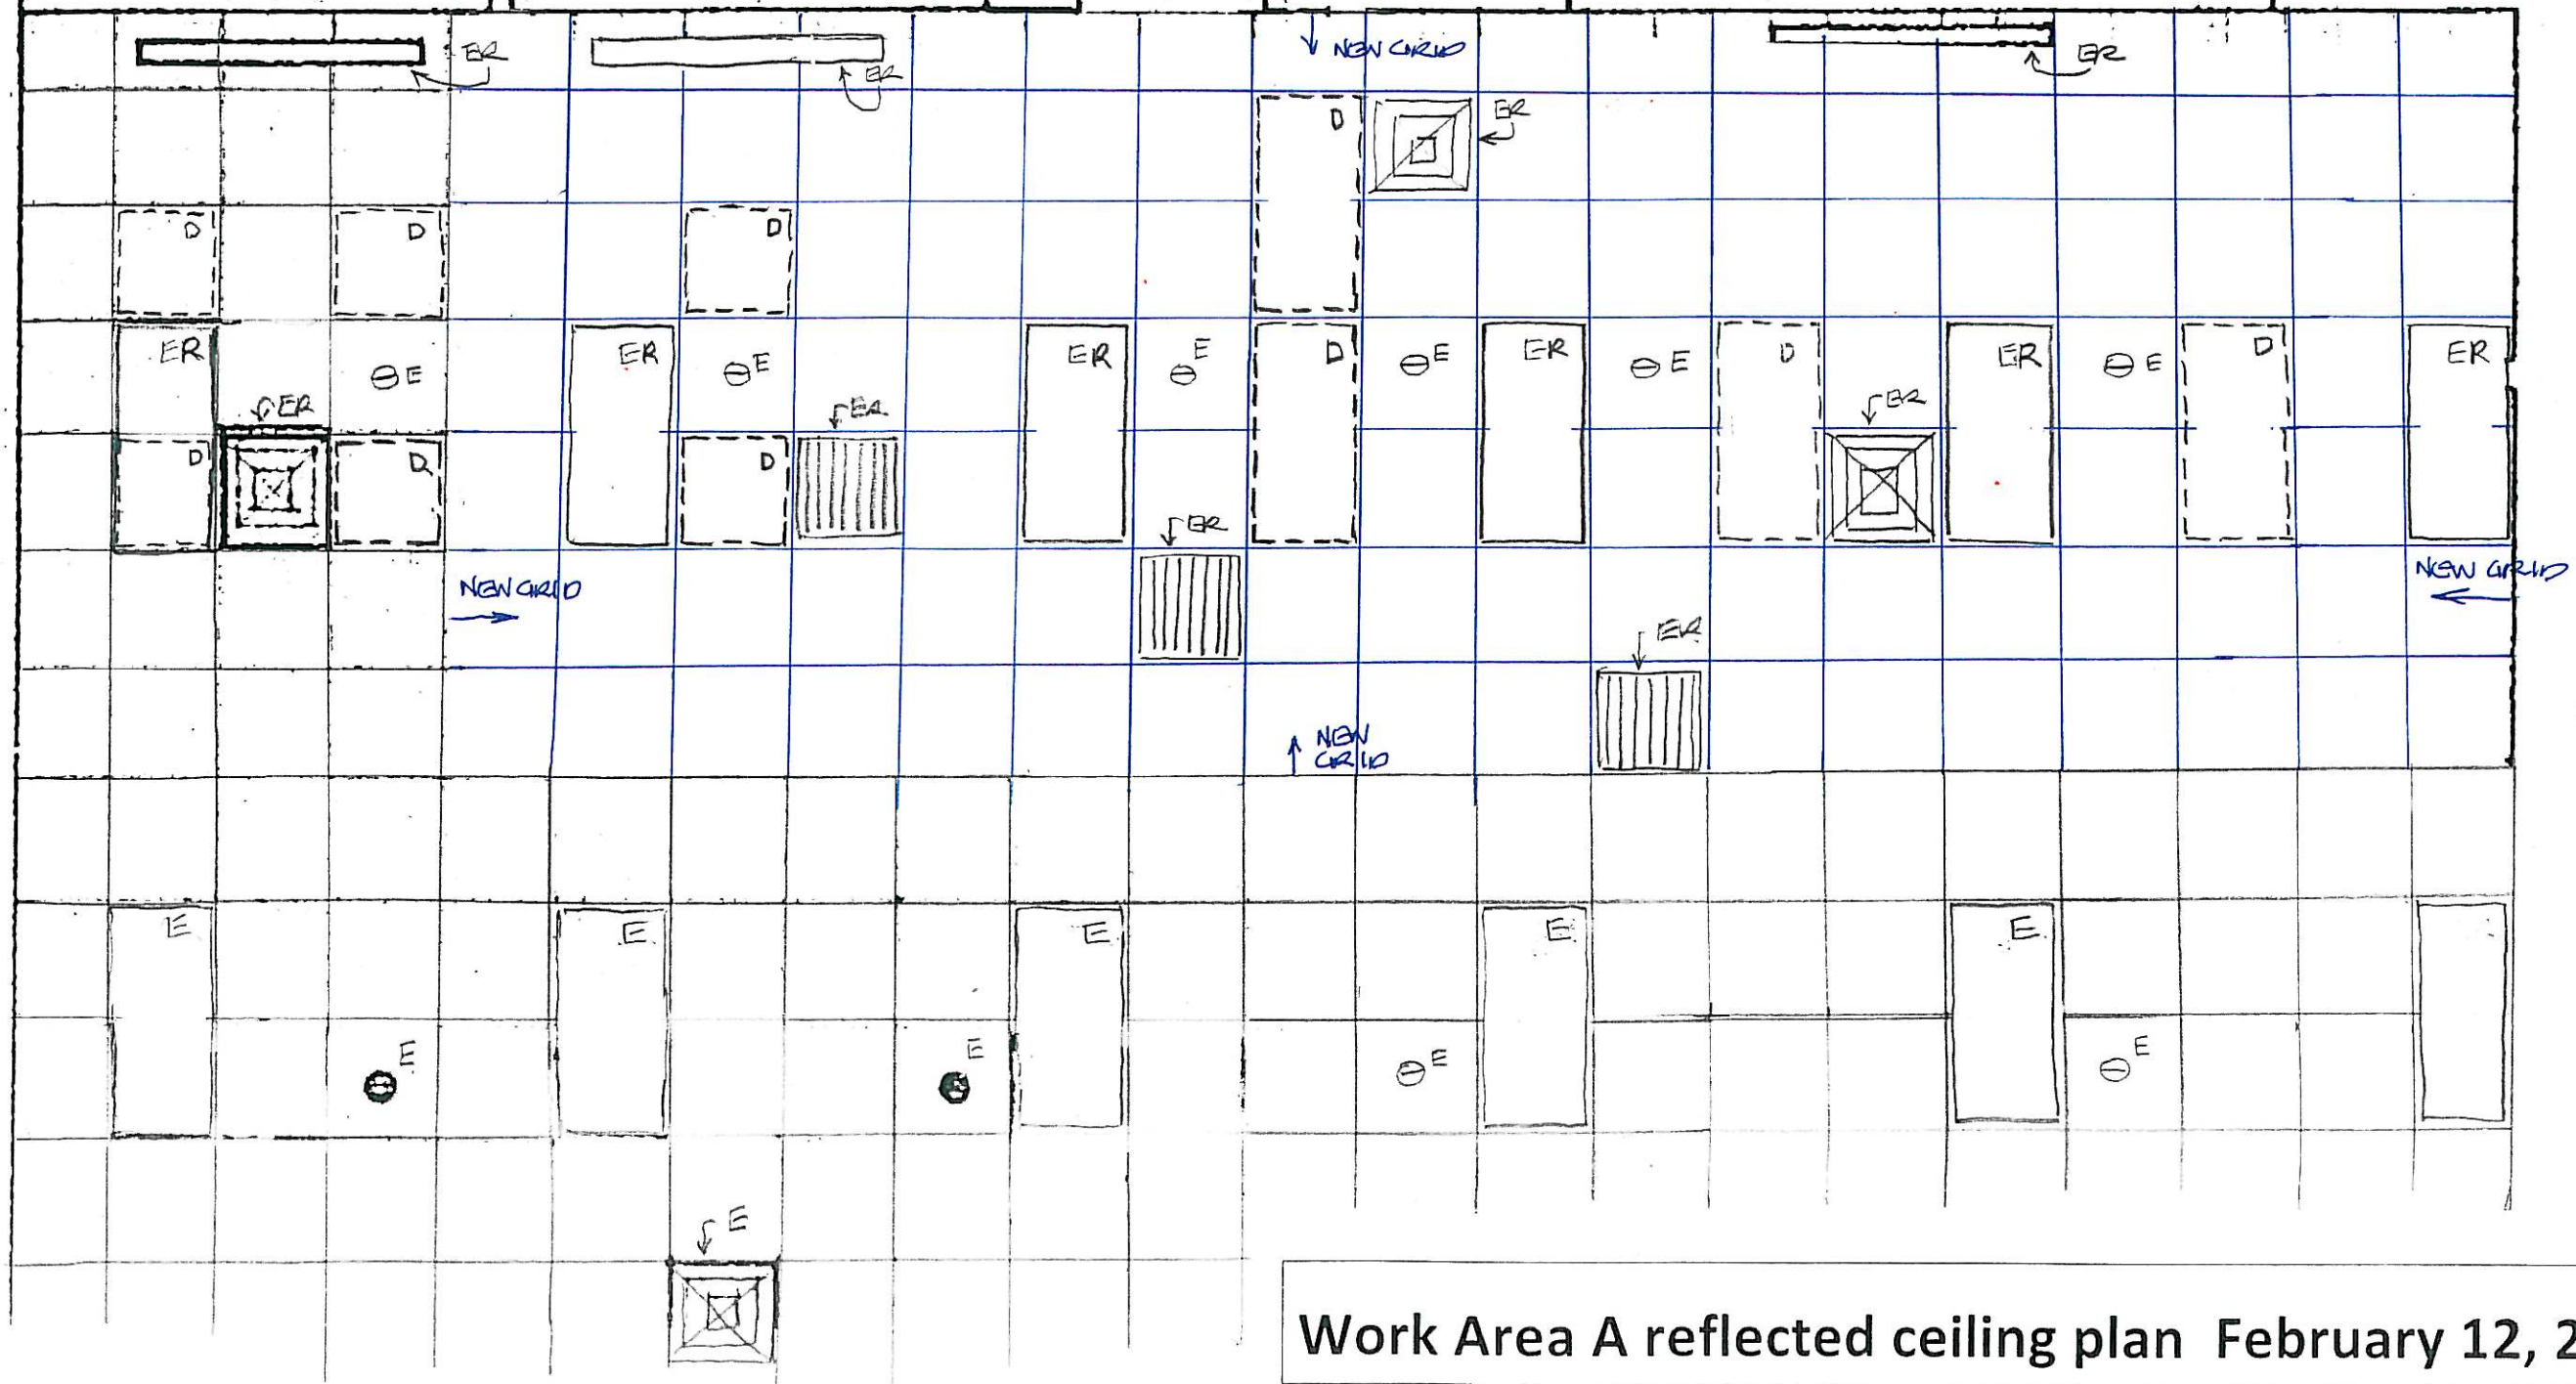


Work Area A reflected ceiling plan February 12, 2011

Office and toilet room remodeling work


Creation Technologies - 1475 S. Wheeling Road, Wheeling, IL

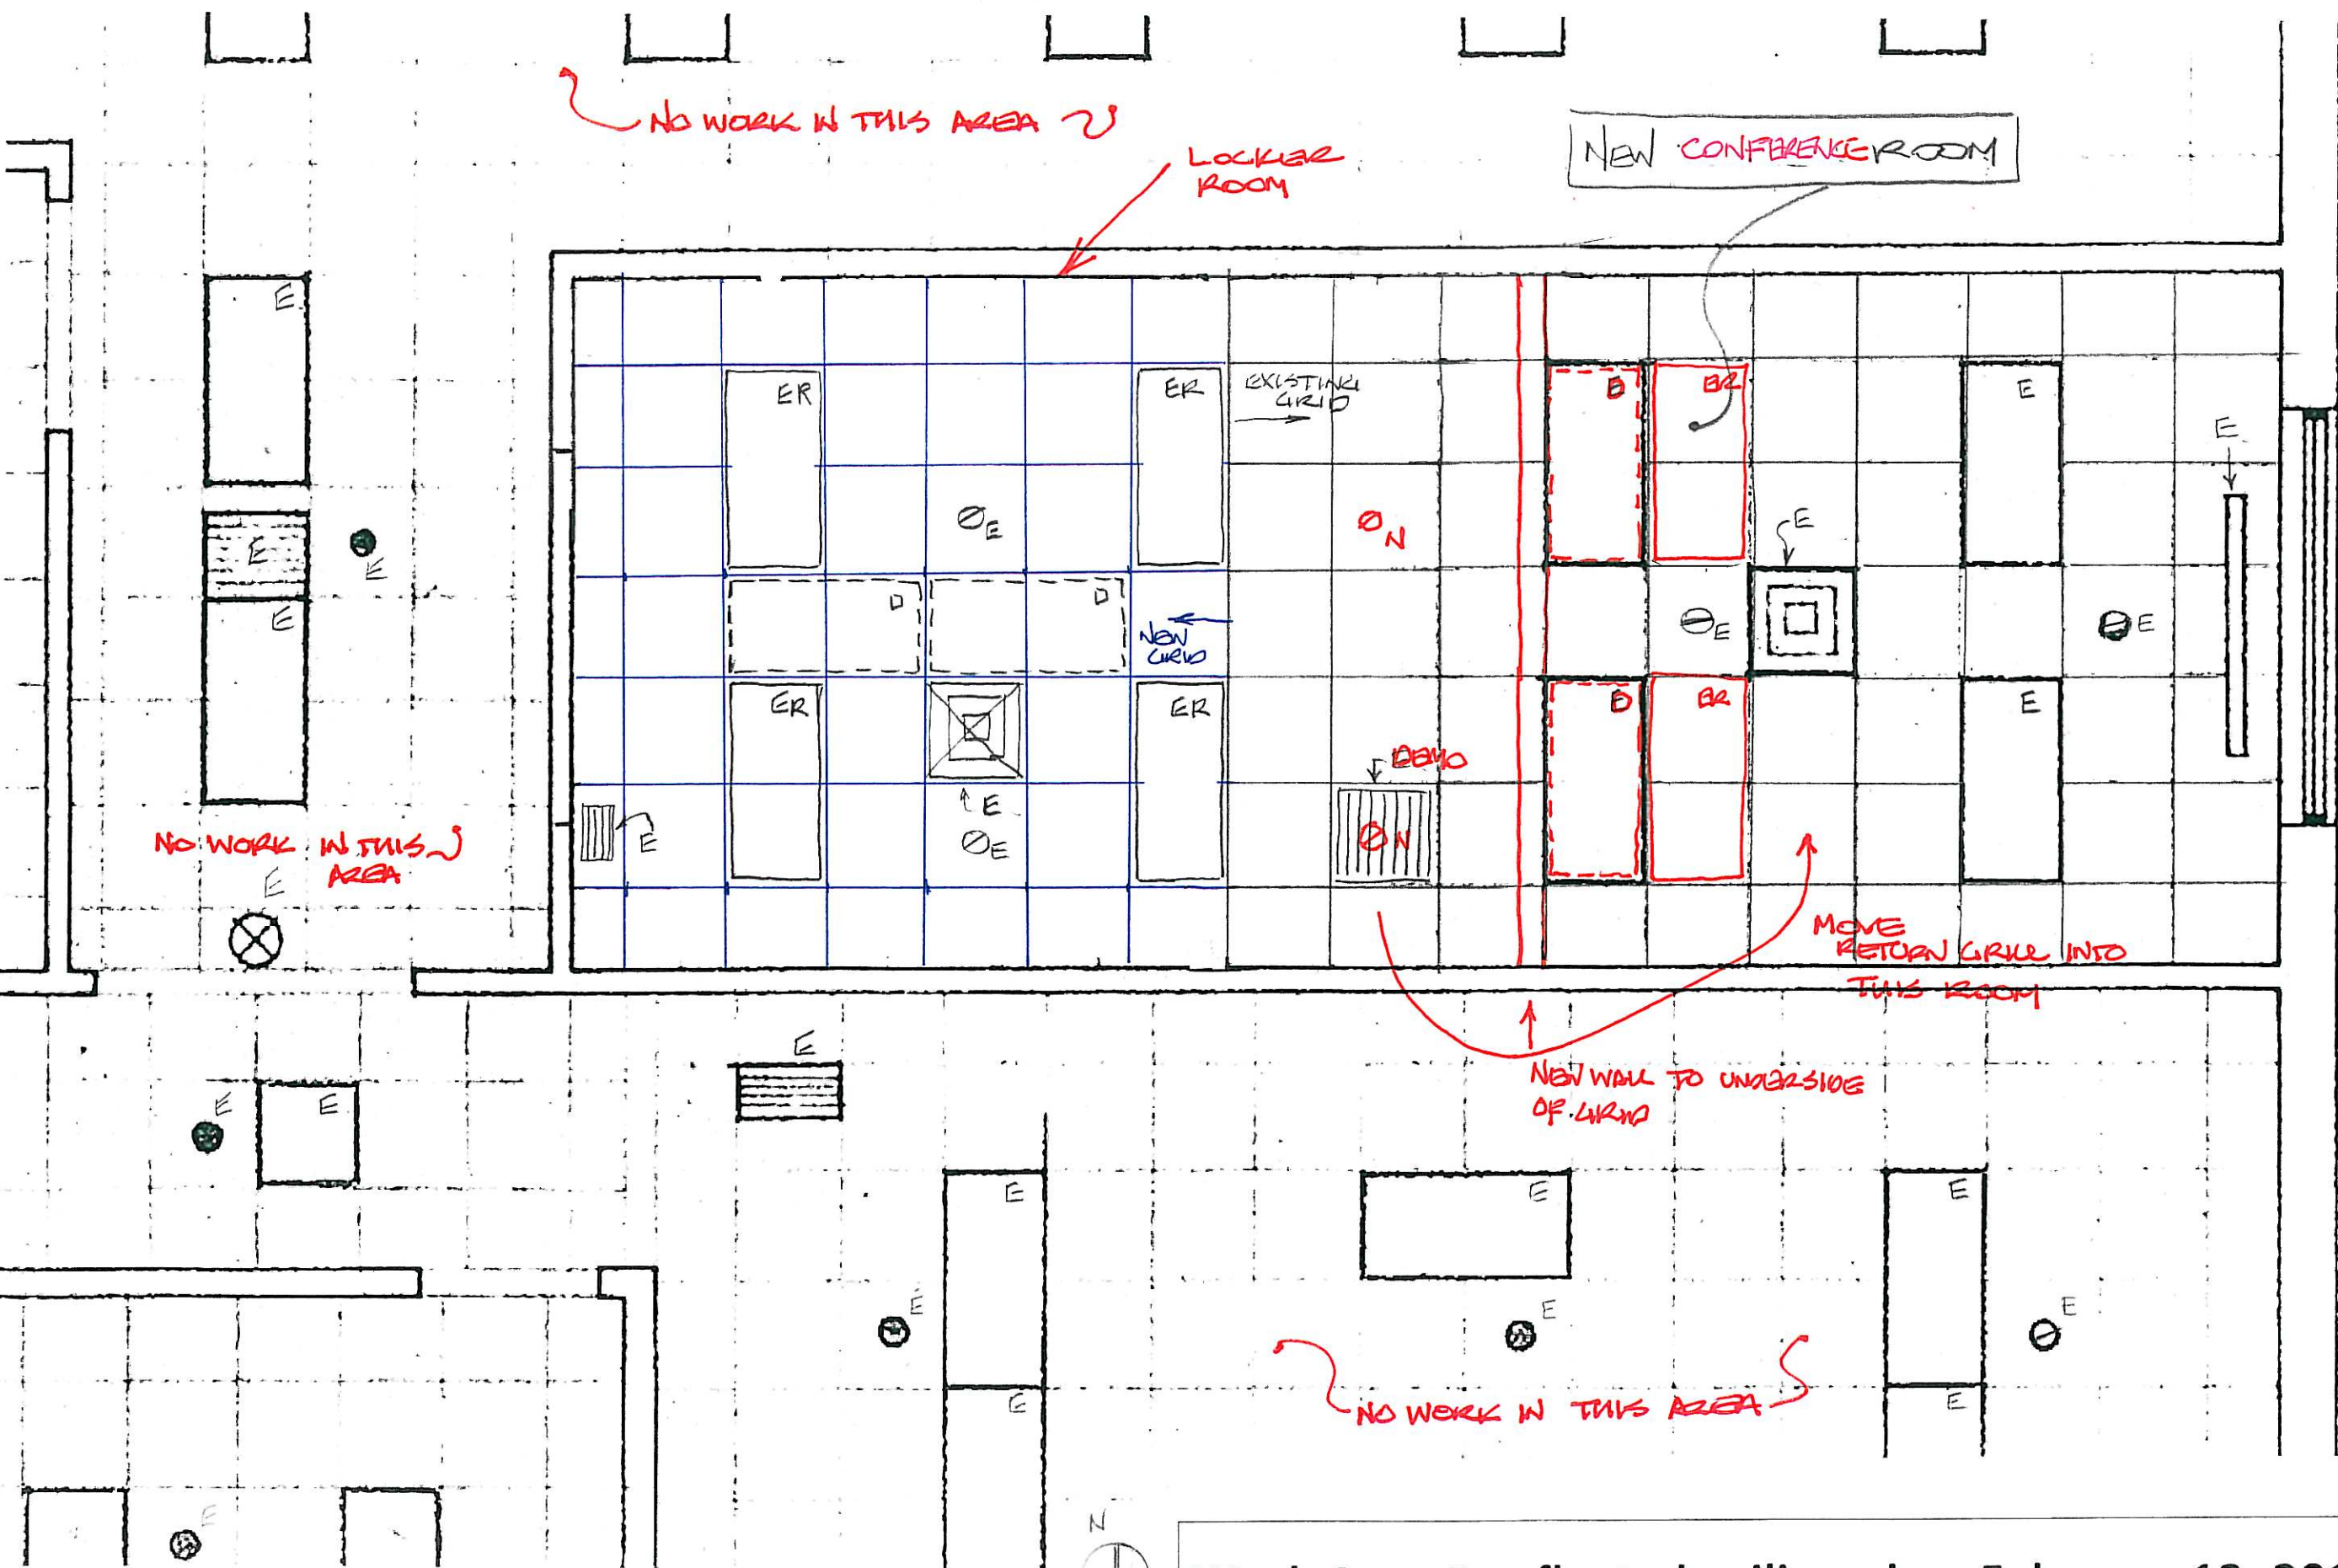


Work Area B reflected ceiling plan February 12, 2011

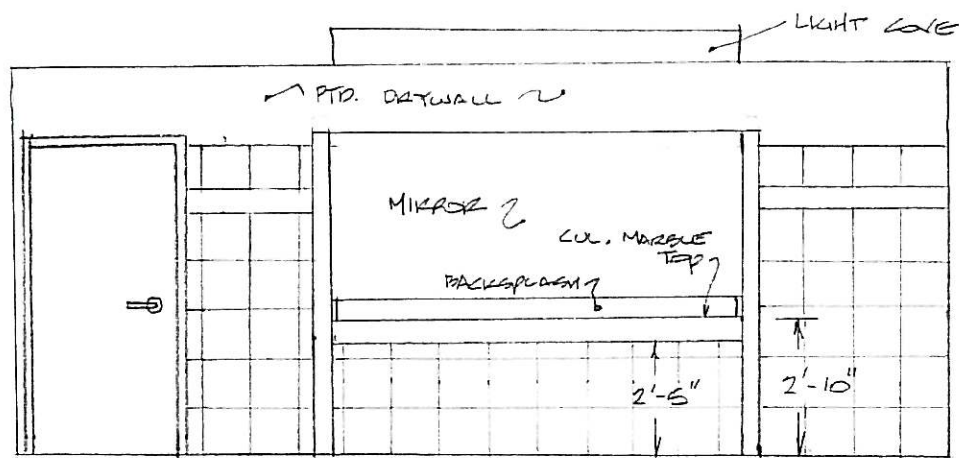


NORTH ELEVATION @ WOMEN'S SECTION A-A

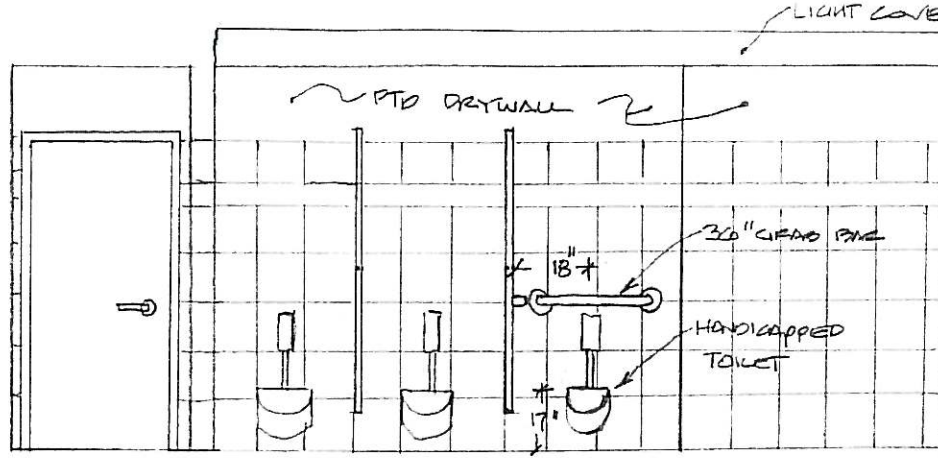


SOUTH ELEVATION @ WOMEN'S SECTION B-B

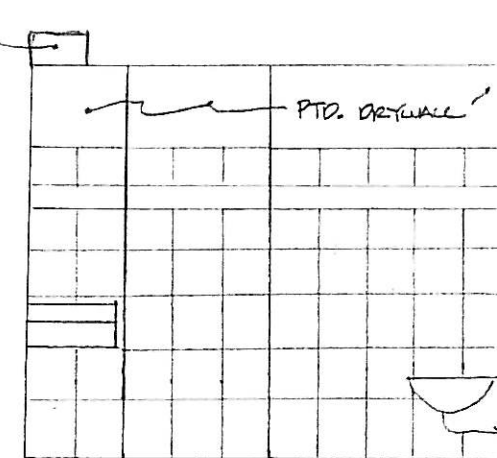


EAST ELEVATION @ WOMEN'S C-C

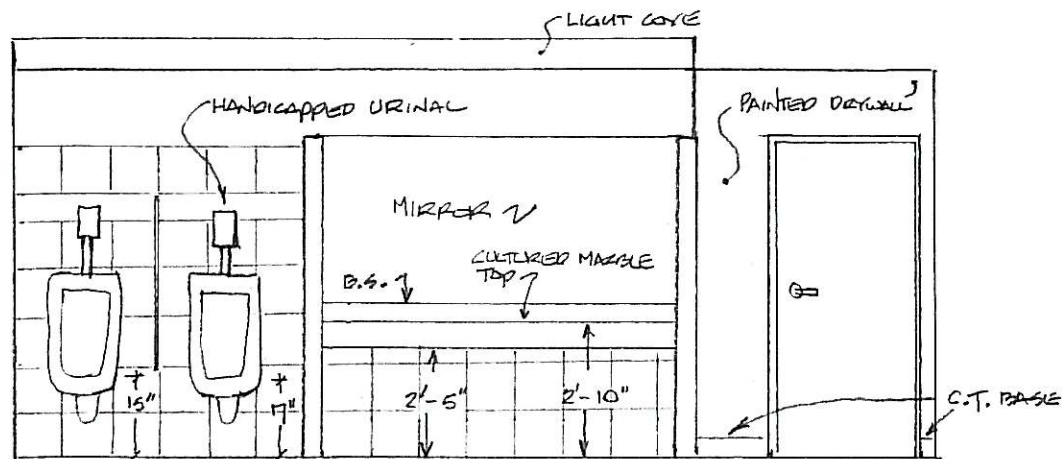


SOUTH ELEVATION @ MEN'S SECTION D-D

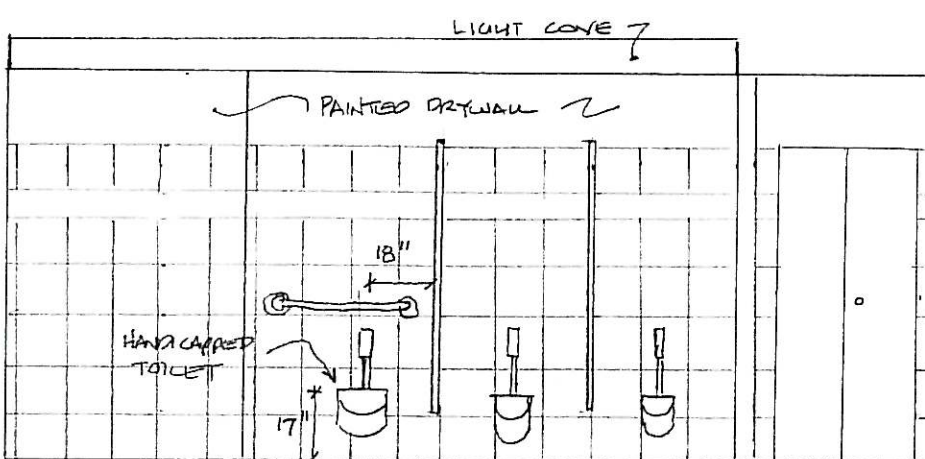


NORTH ELEVATION @ MEN'S SECTION E-E

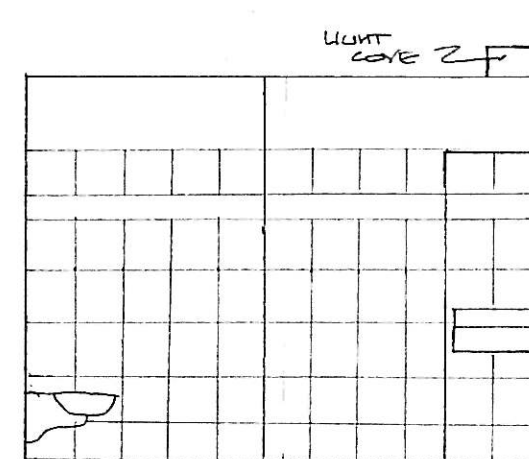

EAST ELEVATION @ MEN'S F-F

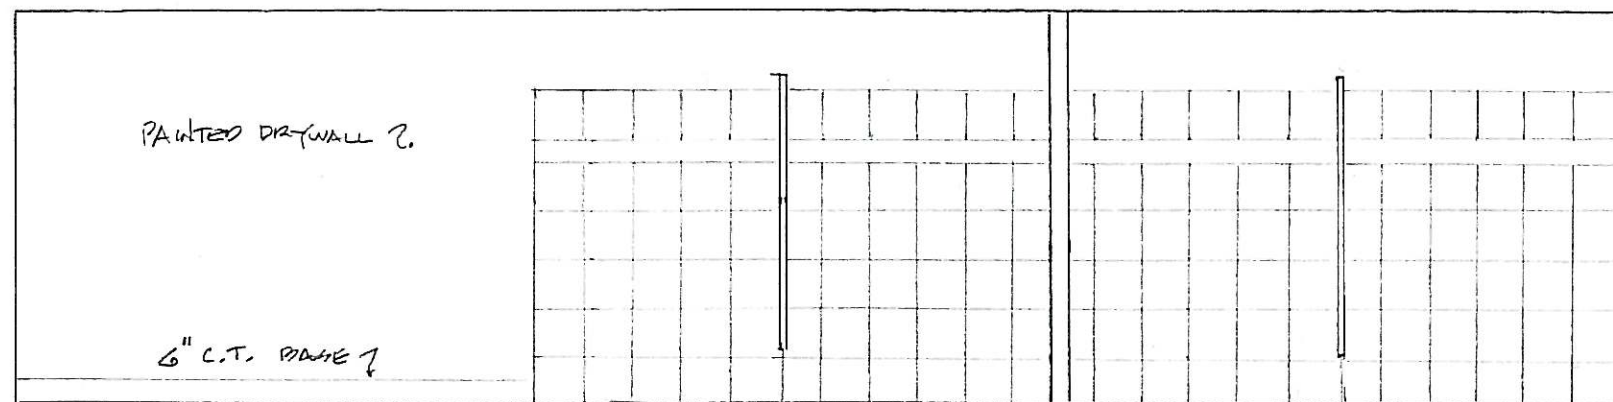

WEST ELEVATION @ MEN'S & WOMEN'S SECTION G-G

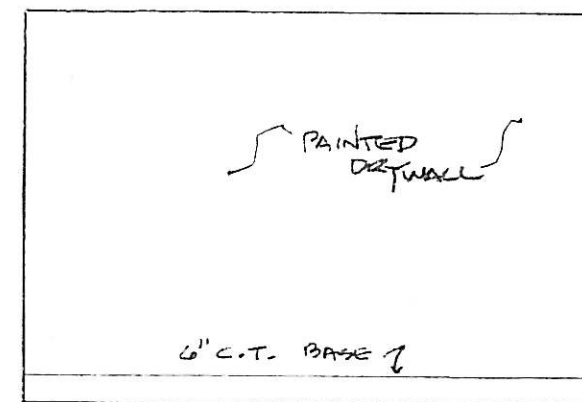

EAST ELEVATION @ MEN'S CORRIDOR

SIMILAR TOILET ROOM ELEVATIONS

Office and toilet room remodeling work

Creation Technologies - 1475 S. Wheeling Road, Wheeling, IL