



INSPIRED TECHNOLOGY CONCEPTS.  
1433, TONNE ROAD, ELK GROVE, IL 60007  
Tel # 847-770-5725

LEXTECT DESIGNS  
912 HAYDEN DR.  
MCHENRY, IL 60050  
303-526-8158  
LEXTECT@PEAKPEAK.COM

ARCHITECT/ENGINEER

LUCACCIONI OFFICE REMODEL  
721 DUNDEE AVE., ELGIN, IL

PROJECT NUMBER:  
14.009

DRAWN BY:  
LP

CHECKED BY:

DATE: REVISION:

DATE: ISSUED AS:  
2-26-15 PRELIMINARY DESIGN  
9-16-15 PERMIT SUBMITTAL  
10-28-15 PERMIT REVISION  
10-10-16 PERMIT RE-SUBMITTAL  
10-19-16 ISSUE FOR PRICING


SHEET TITLE:

LIGHTING AND POWER LAYOUT


SHEET NUMBER:

E-01


© All drawings and written material contained herein may not be duplicated, used or disposed without the written consent of the architect.

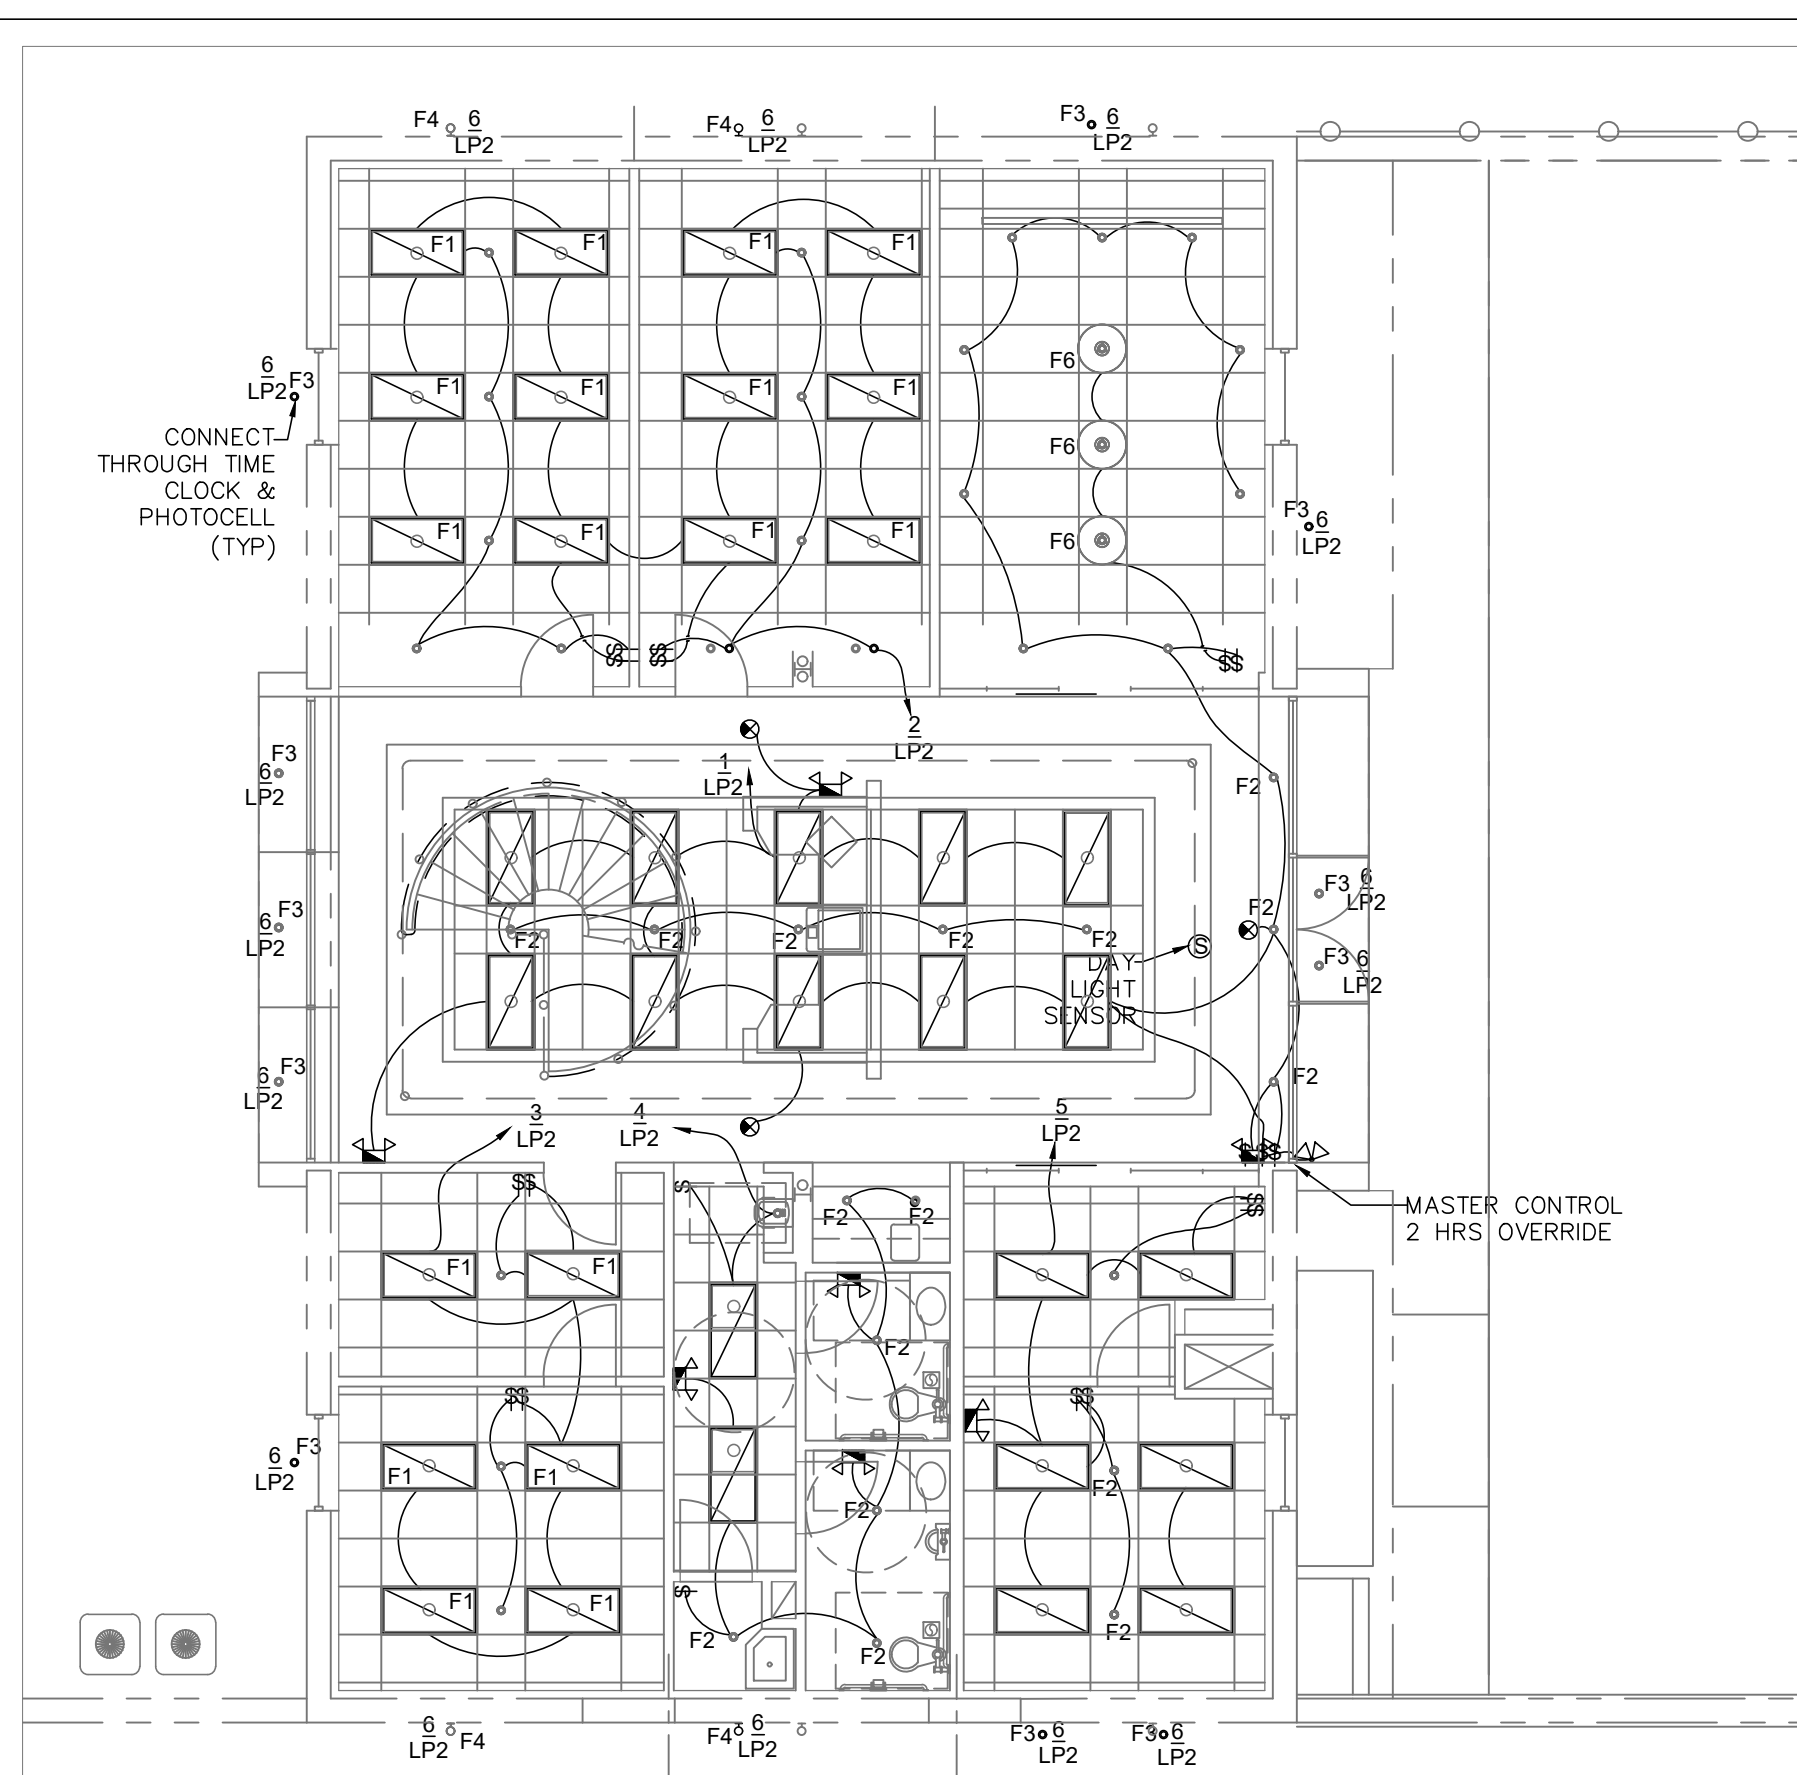


MAIN LEVEL LIGHTING LAYOUT  
SCALE: 1/8" = 1'-0"

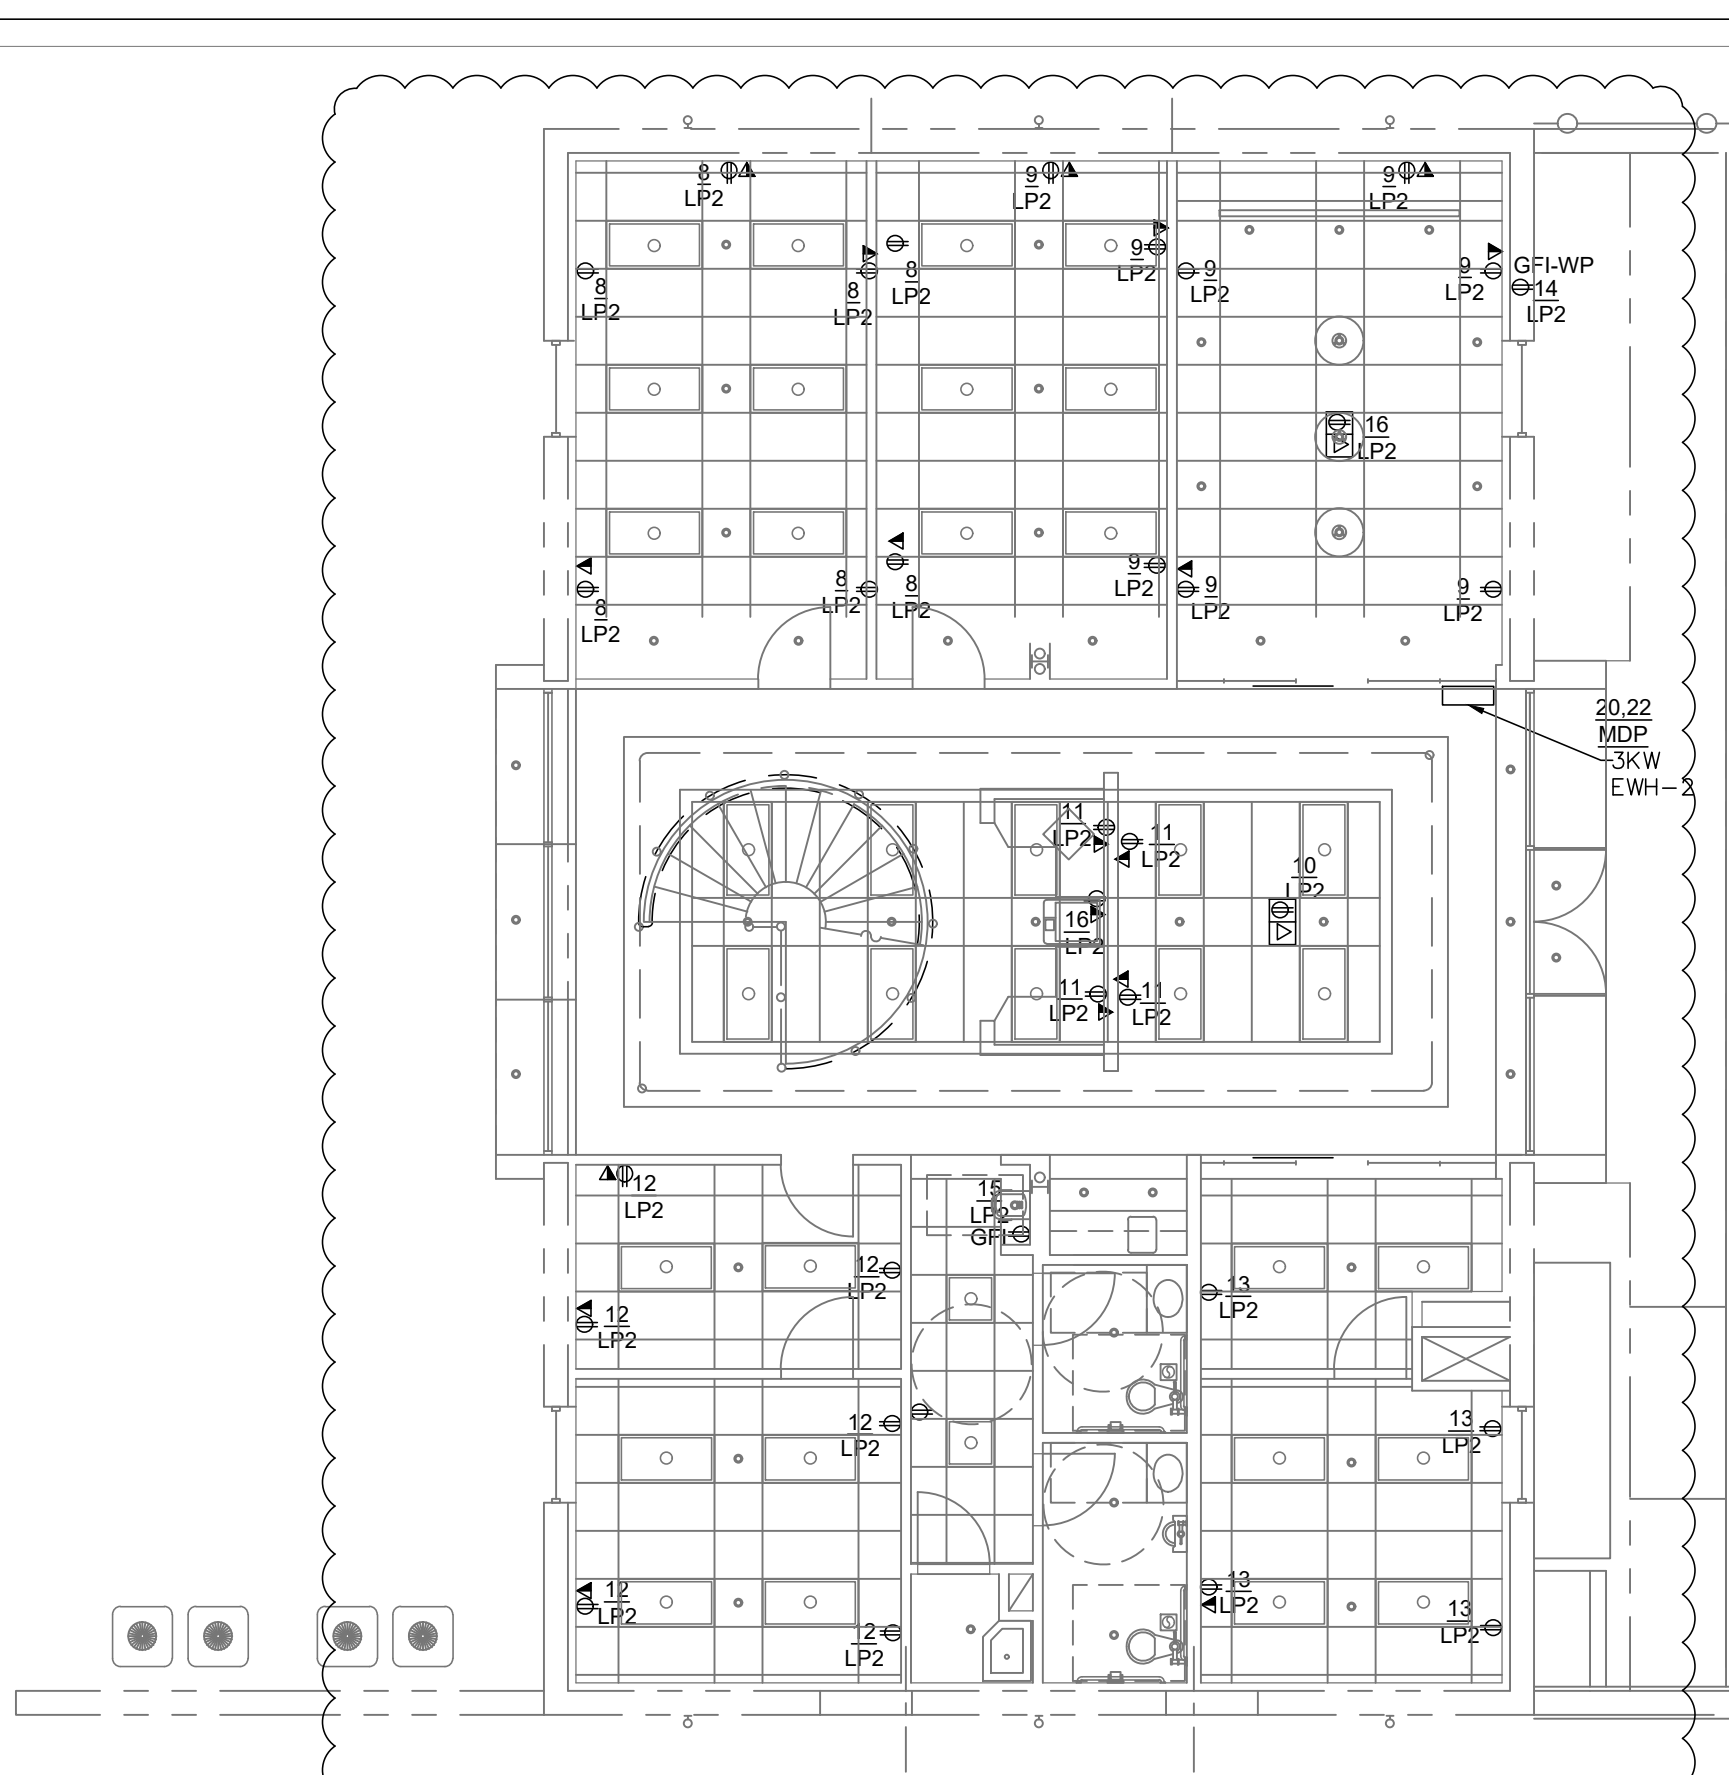


MAIN LEVEL POWER LAYOUT  
SCALE: 1/8" = 1'-0"

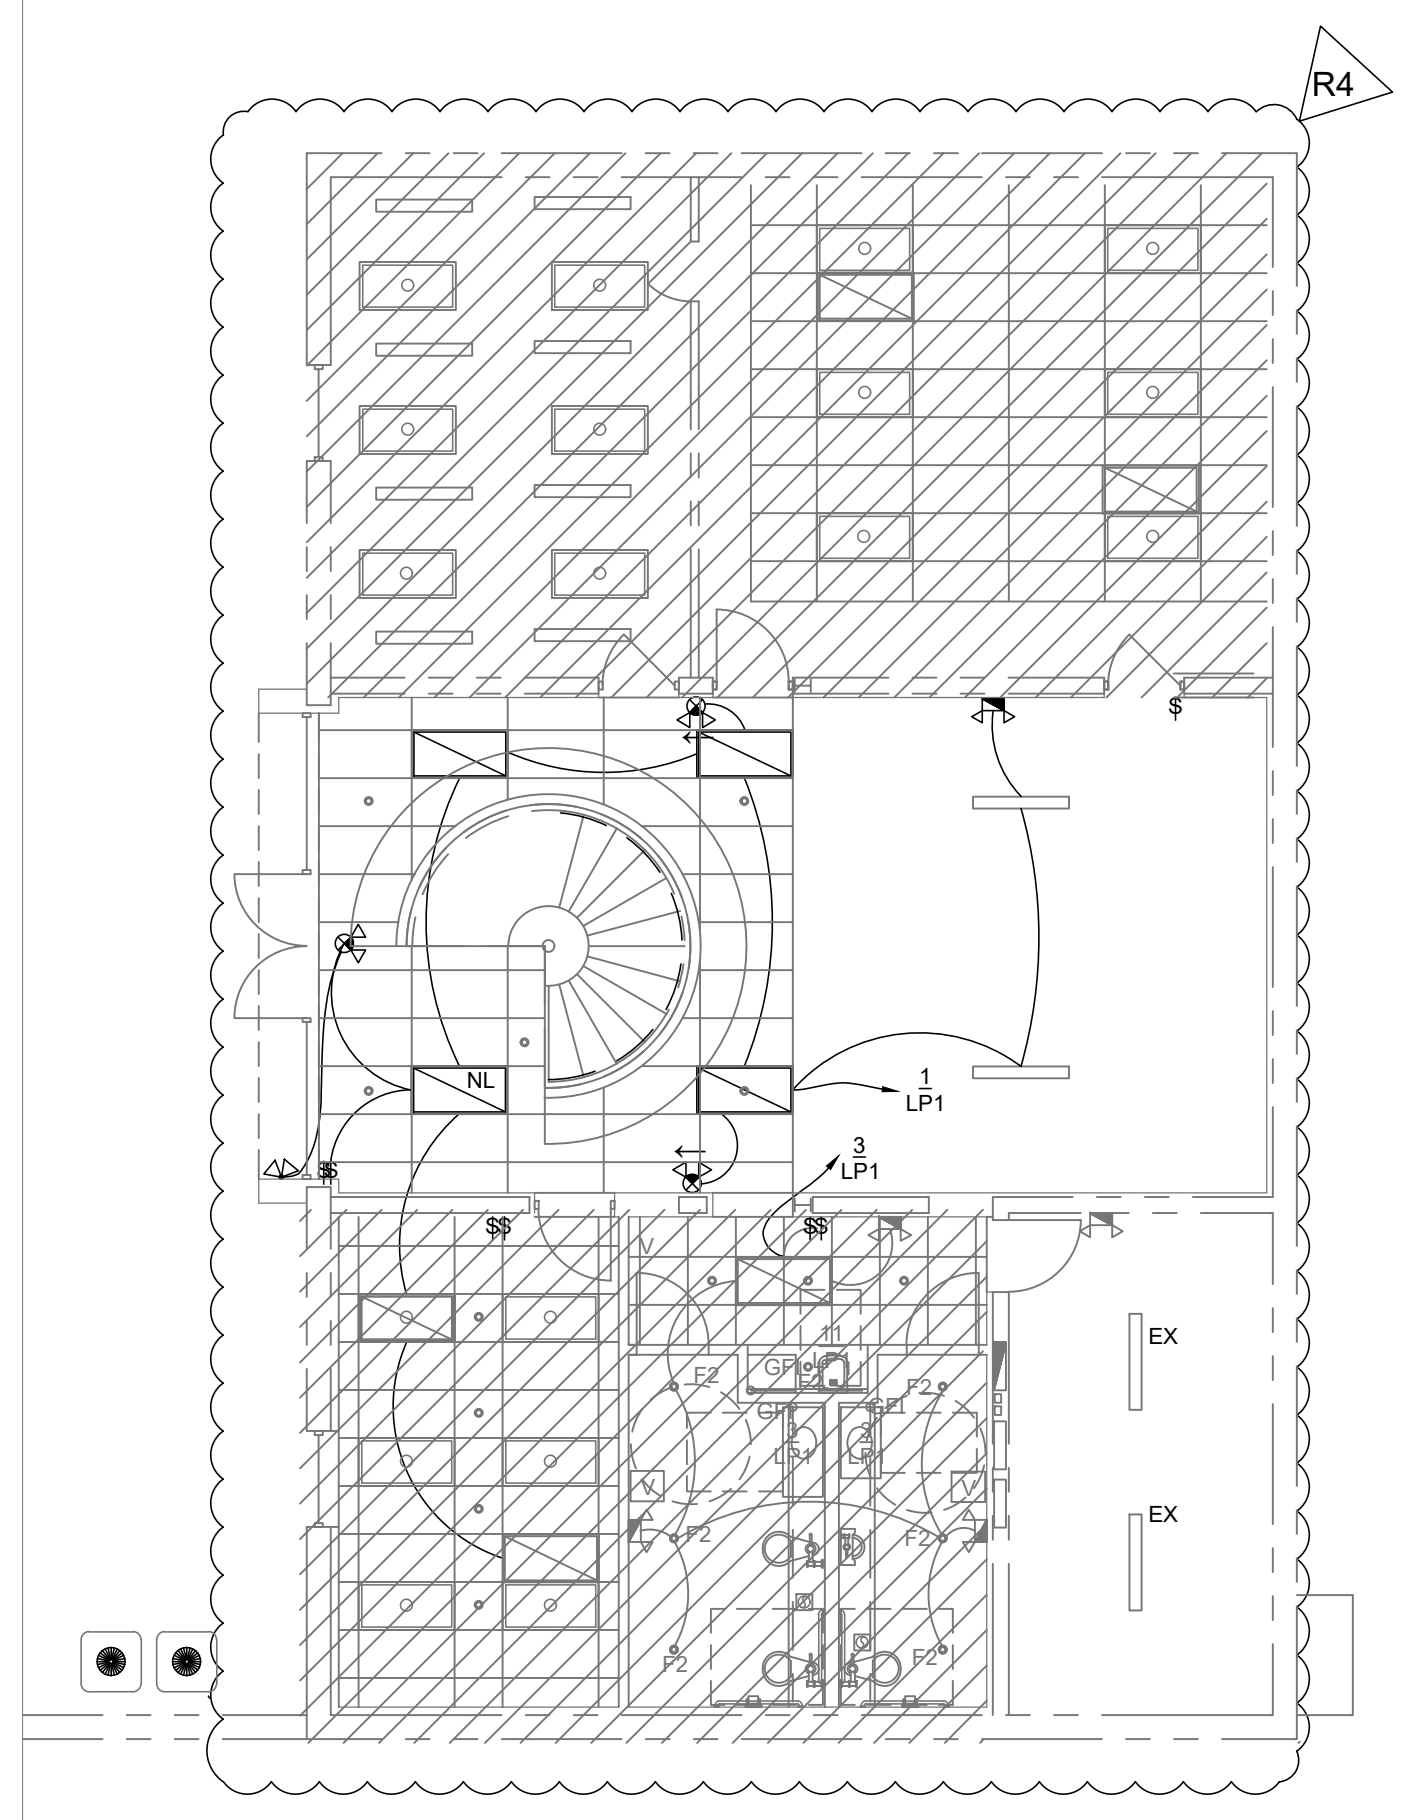

LOWER LEVEL LIGHTING LAYOUT  
SCALE: 1/8" = 1'-0"


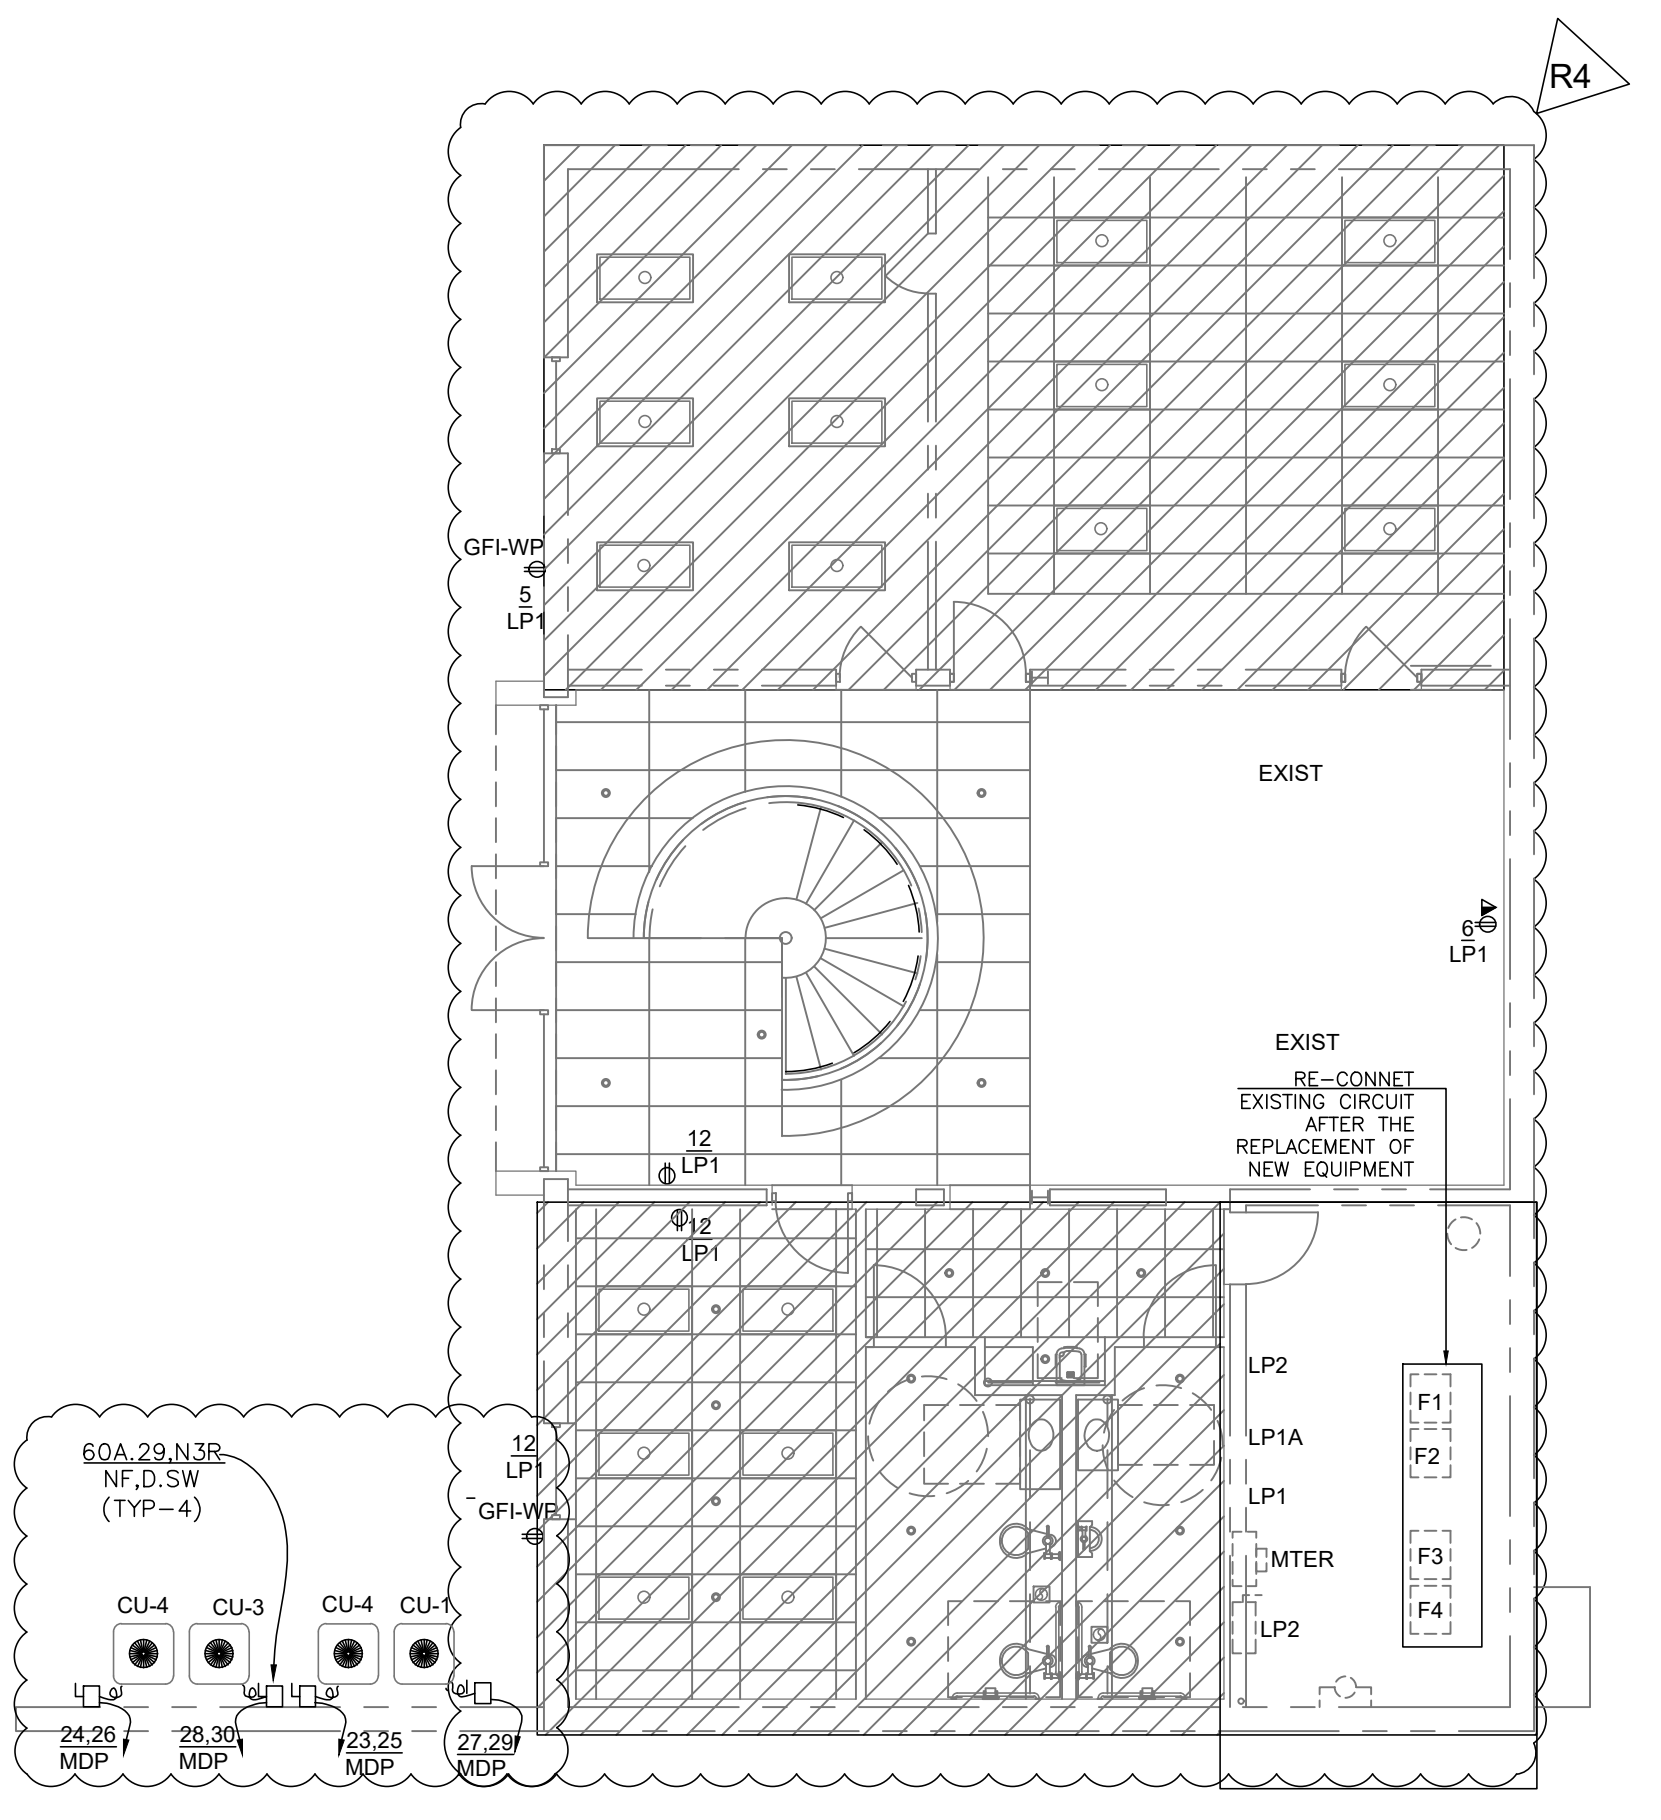


MAIN LEVEL POWER LAYOUT  
SCALE: 1/8" = 1'-0"

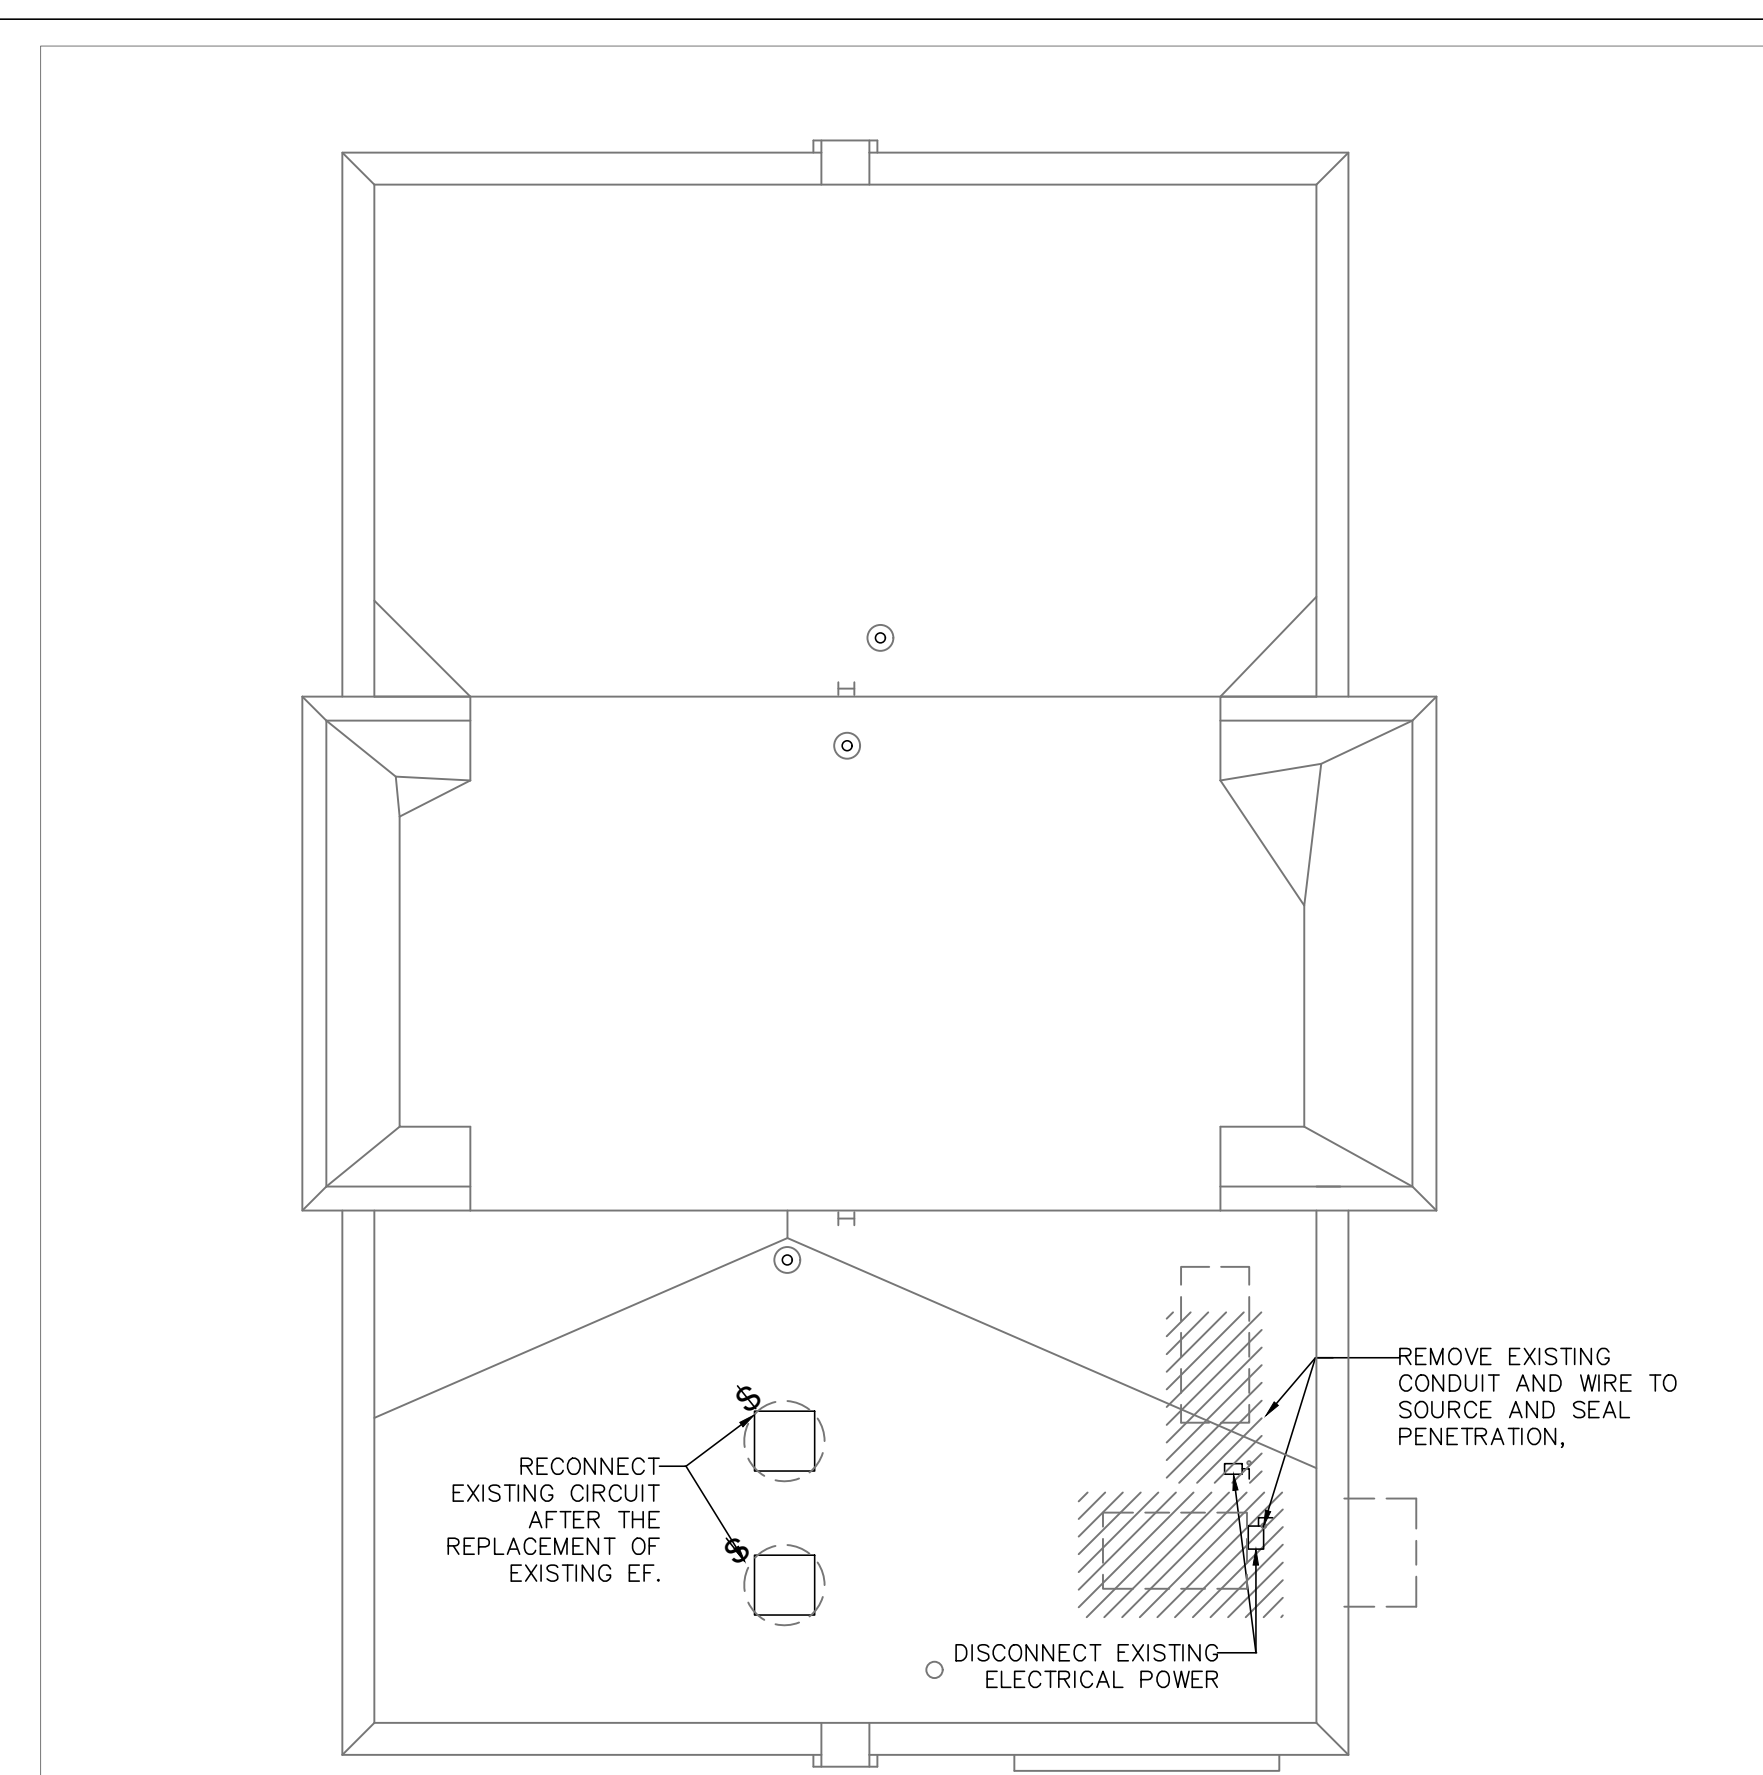

ROOF ELECTRICAL LAYOUT  
SCALE: 1/8" = 1'-0" MIRROR LINE

LIGHTING FIXTURE SCHEDULE								
TYPE	DESCRIPTION	MANUFACTURER AND NUMBER	CATALOG	MOUNTING	LAMP DATA		VOLT	NOTES
					QTY	WATT		
F1	2X4 TROFFER	METALUX # 2GR-LD1-48-A-UNV-L840-CD1-U		RECESSED	1	48	120	
F2	6" RECESSED CAN	HALO # PD618ED010,PDM6840,61VC		RECESSED	1	17.1	120	
F3	6" RECESSED CAN - LENSED	HALO # PD610ED010,PDM6A835,61VC		RECESSED	1	12.1	120	
F4	WALL SCONCE	RAB LIGHTING # SLM12		WALL MOUNT	1	12	120	
F5	LED PANEL	TDB		RECESSED	1	100	120	
F6	DECORATIVE PENDANT LIGHT	TECH LIGHTING # 700TDSARGPSC		PENDANT	1	35W	120	
EM	EMERGENCY LIGHT	LITHONIA # ELM2		SURFACE	INCLUDED	6	120	
EM-1	EMERGENCY LIGHT W/REMOTE CAPABILITY	LITHONIA# ELM2 LED HO		SURFACE	INCLUDED	9	120	
RH	REMOTE HEAD	LITHONIA # ELA T QWP L0304		SURFACE	INCLUDED	-	120	
	EXIT SIGN	LITHONIA # EDGR-EL (SINGLE,DOUBLE FACE)		SURFACE	INCLUDED	-	120	

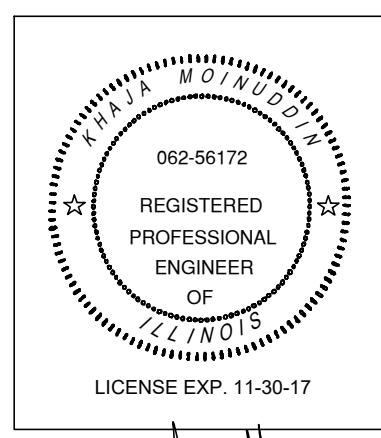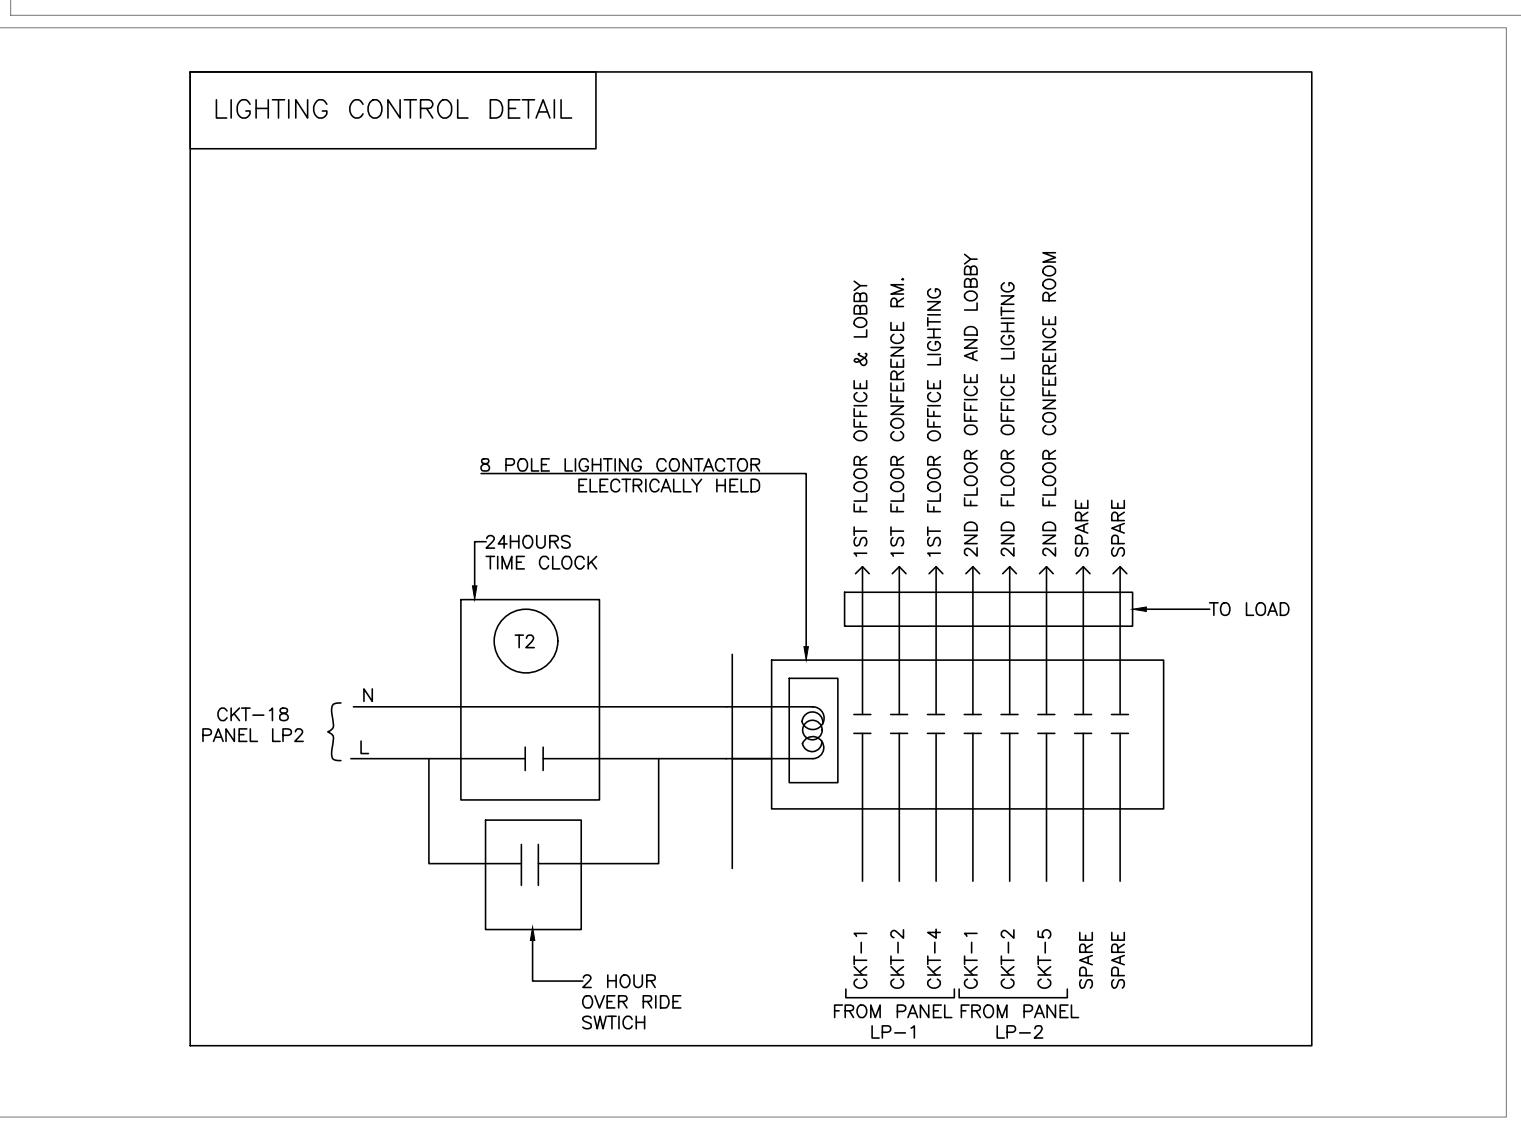

C. Moirand