




MAIN LEVEL WATER & VENT FLOOR PLAN
SCALE: 1/8" = 1'-0"

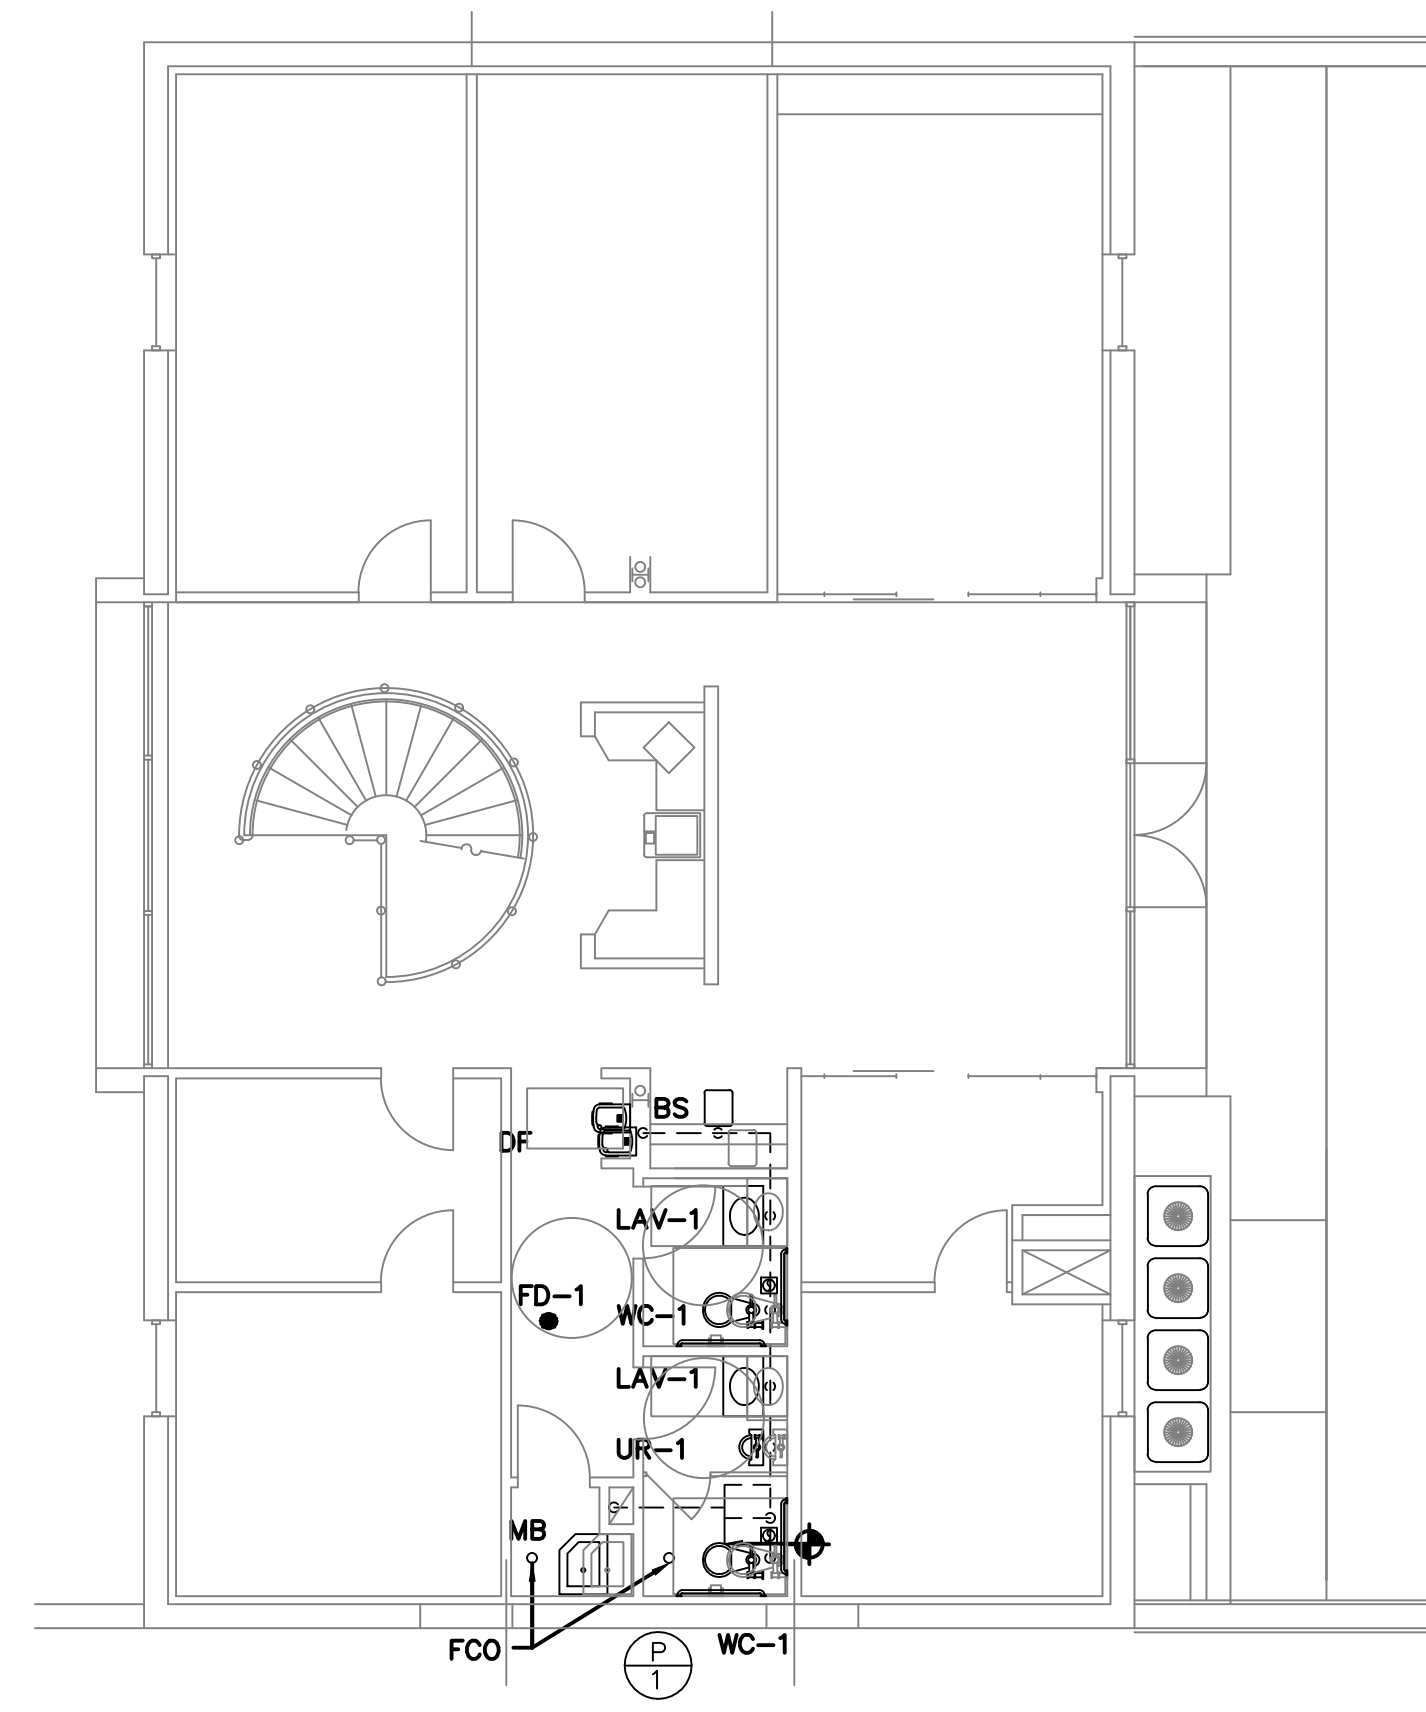


MAIN LEVEL WASTE FLOOR PLAN
SCALE: 1/8" = 1'-0"

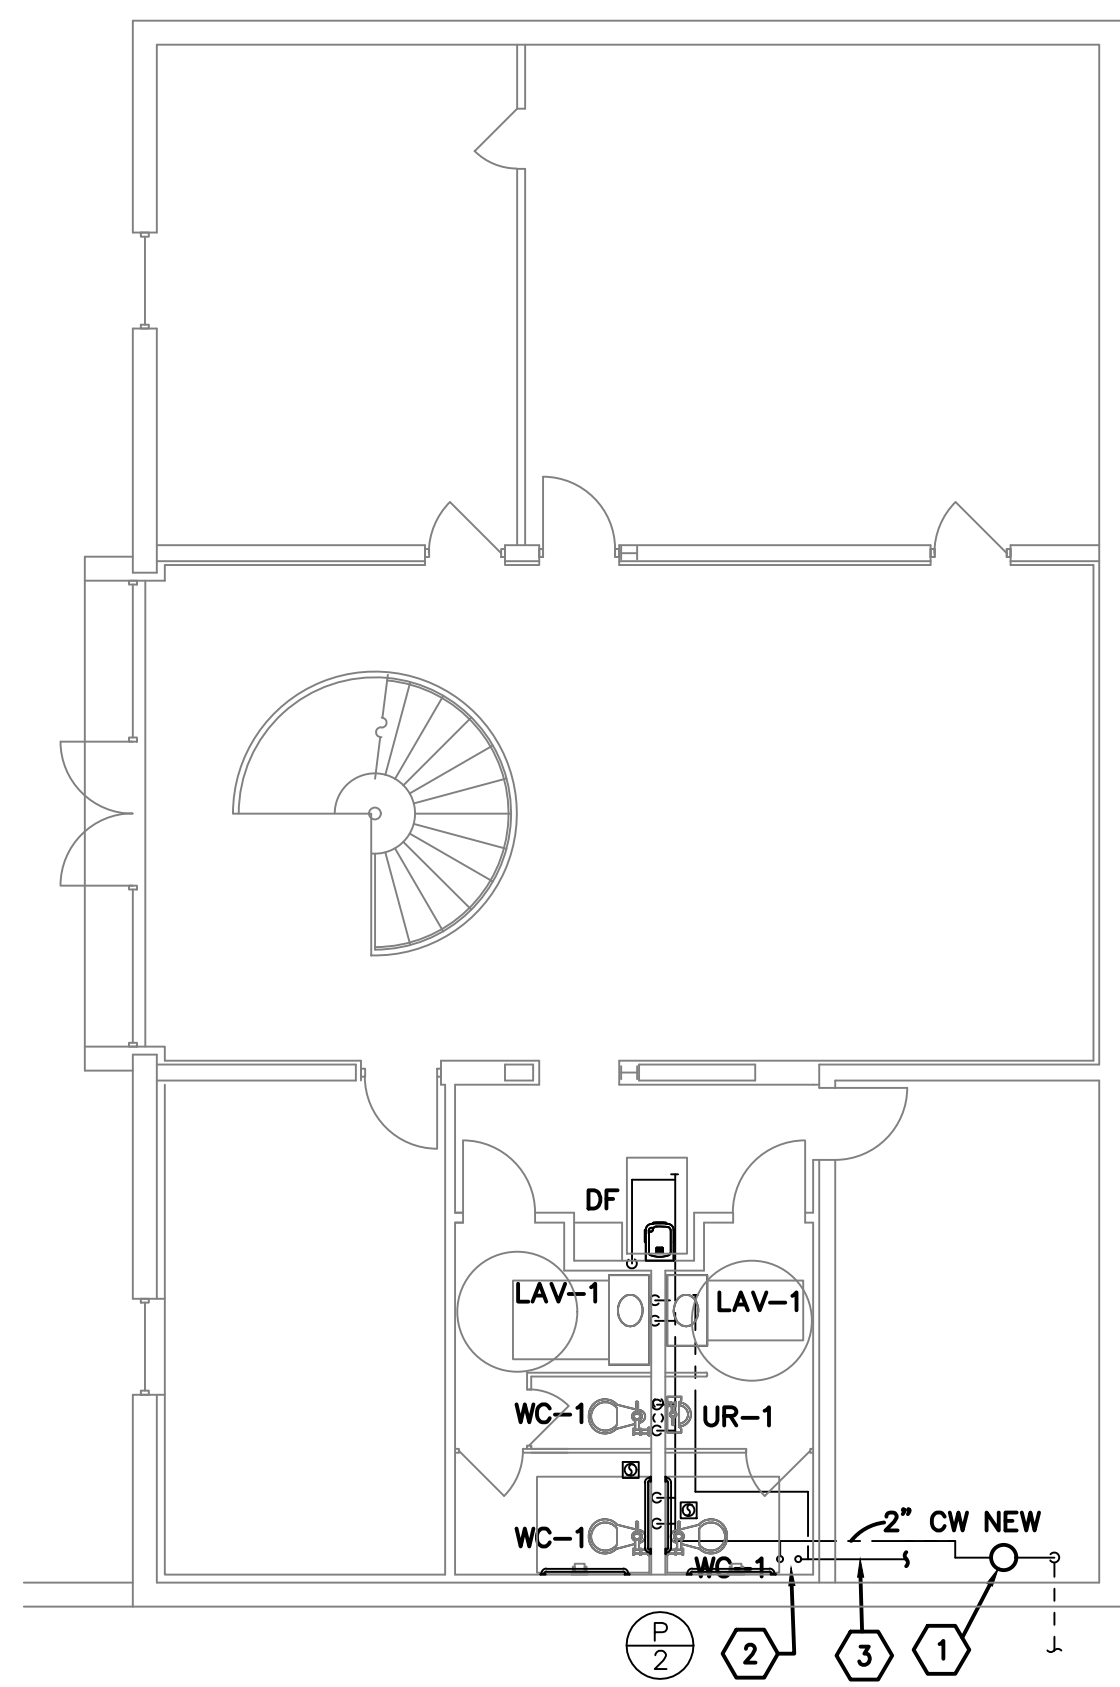

LOWER LEVEL WATER & VENT FLOOR PLAN
SCALE: 1/8" = 1'-0"

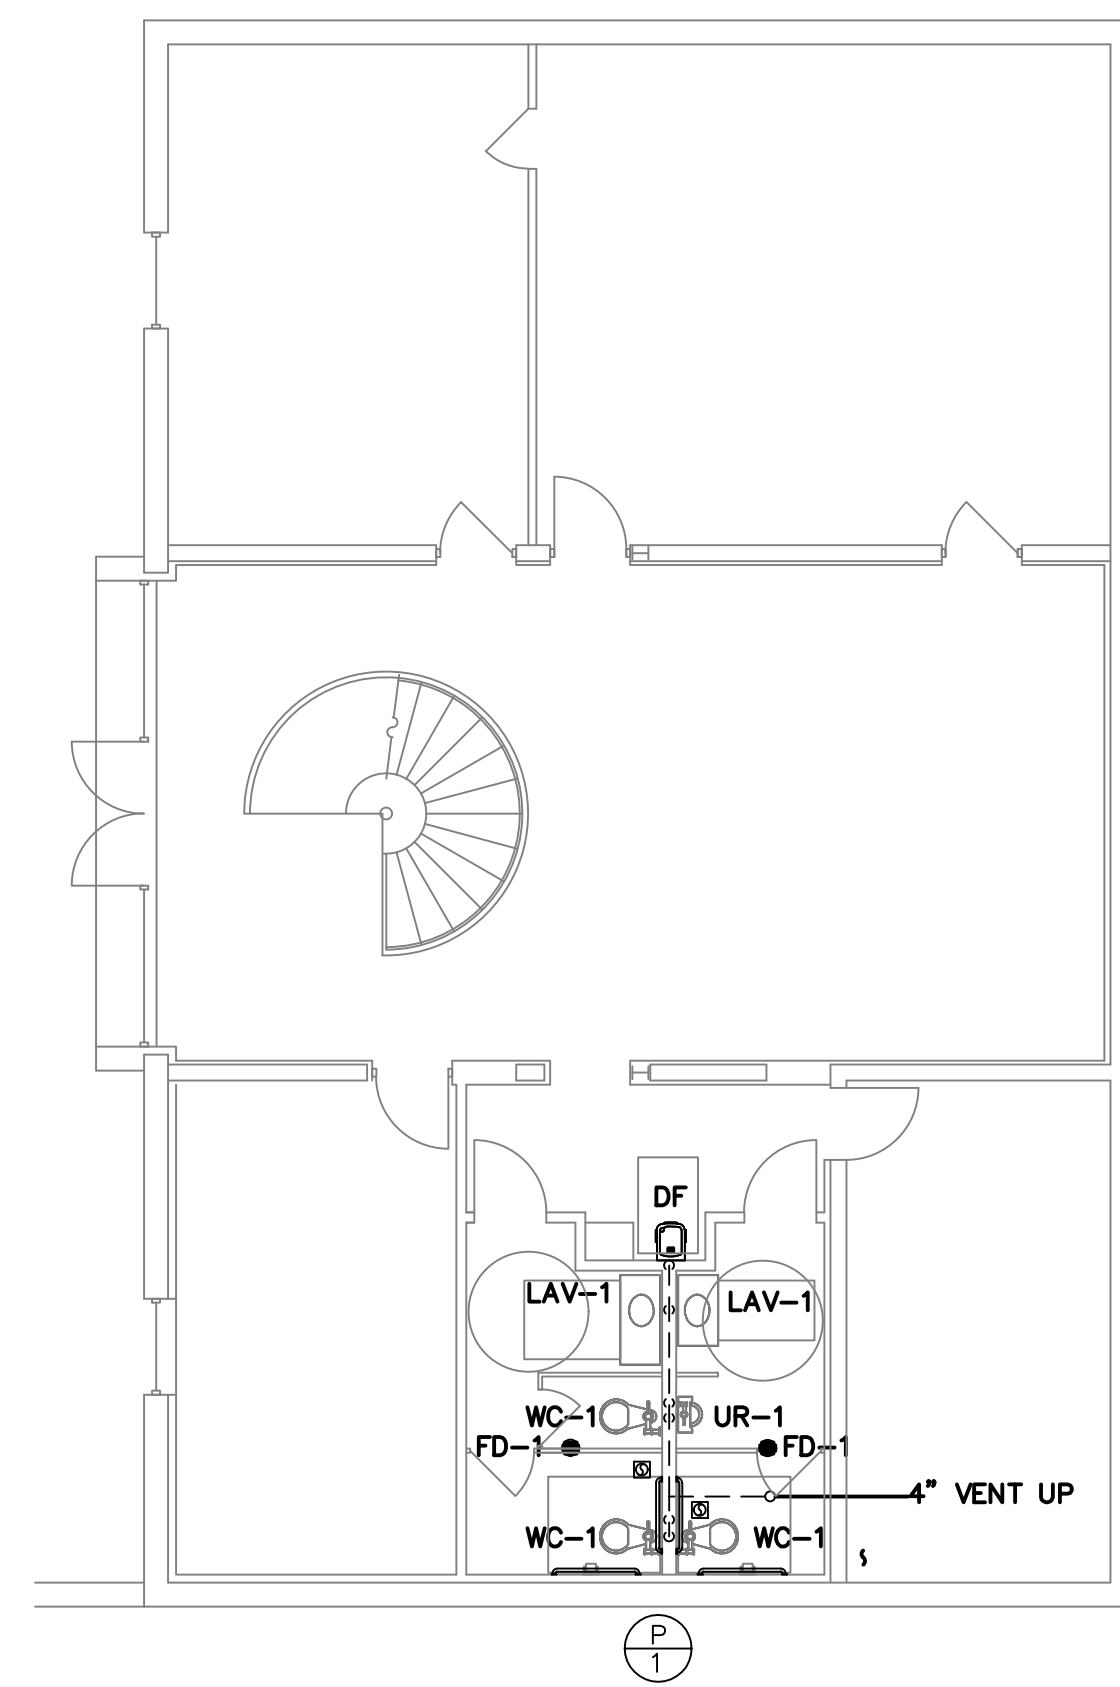

LOWER LEVEL WASTE FLOOR PLAN
SCALE: 1/8" = 1'-0"

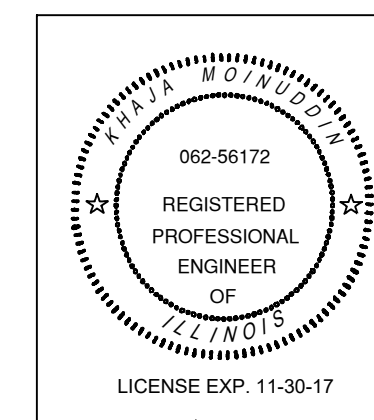

C. Moine



INSPIRED
TECHNOLOGY
CONCEPTS.
1433, TONNE ROAD,
ELK GROVE, IL
60007
Tel # 847-770-5725

LEXTECT DESIGNS
912 HAYDEN DR.
MCHENRY, IL 60050
303-526-8158
LEXTECT@PEAKPEAK.COM

ARCHITECT/ENGINEER

LUCACCIONI
OFFICE REMODEL
721 DUNDEE AVE., ELGIN, IL

PROJECT NUMBER:
14.009

DRAWN BY:
LP

CHECKED BY:

DATE:	REVISION:

DATE:	ISSUED AS:
2-26-15	PRELIMINARY DESIGN
9-16-15	PERMIT SUBMITTAL
10-28-15	PERMIT REVISION
10-10-16	PERMIT RE-SUBMITTAL
10-19-16	ISSUE FOR PRICING

SHEET TITLE:
PLUMBING FLOOR
PLANS

SHEET NUMBER:

P-01