



INSPIRED
TECHNOLOGY
CONCEPTS.
1433, TONNE ROAD,
ELK GROVE, IL
60007
Tel # 847-770-5725

LEXTECT DESIGNS
912 HAYDEN DR.
MCHENRY, IL 60050
303-526-8158
LEXTECTDESIGNS.COM

ARCHITECT/ENGINEER

LUCACCIONI
OFFICE REMODEL
721 DUNDEE AVE., ELGIN, IL

PROJECT NUMBER:
14.009

DRAWN BY:
LP

CHECKED BY:

DATE: REVISION:

.
. .
. .
. .
. .

DATE: ISSUED AS:


2-26-15 PRELIMINARY DESIGN
9-16-15 PERMIT SUBMITTAL
10-28-15 PERMIT REVISION
10-10-16 PERMIT RE-SUBMITTAL
10-19-16 ISSUE FOR PRICING

SHEET TITLE:

PLUMBING DEMO
FLOOR PLANS

SHEET NUMBER:

PD1

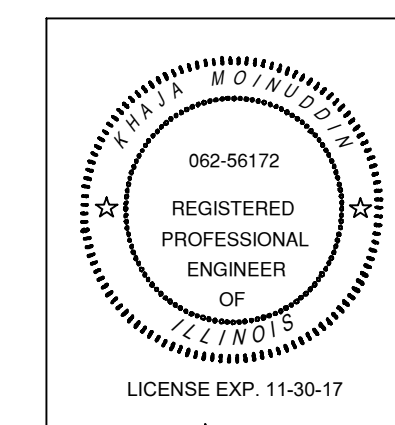

C. Moir


© All drawings and written material contained herein may not be duplicated, used or disposed without the written consent of the architect.

DEMOLITION LEGEND


- (EX) ITEM IS EXISTING TO REMAIN
- (X) ITEM IS EXISTING TO BE REMOVED
- (XR) ITEM IS EXISTING TO BE RELOCATED

PLUMBING DRAWING KEYNOTES

- 1 REMOVE DRAIN.
- 2 CAP SUSPENDED WASTE PIPING BELOW FLOOR. REMOVE VENT BACK TO MAIN AND CAP.
- 3 REMOVE WATER PIPING BACK TO MAIN AND CAP.
- 4 EXISTING VENT THRU ROOF TO REMAIN. CAP BELOW THE ROOF.
- 5 EXISTING WATER METER TO BE REMOVED AND UPGRADE. SEE P100 SHEET.
- 6 EXISTING MOP SINK TO REMAIN.

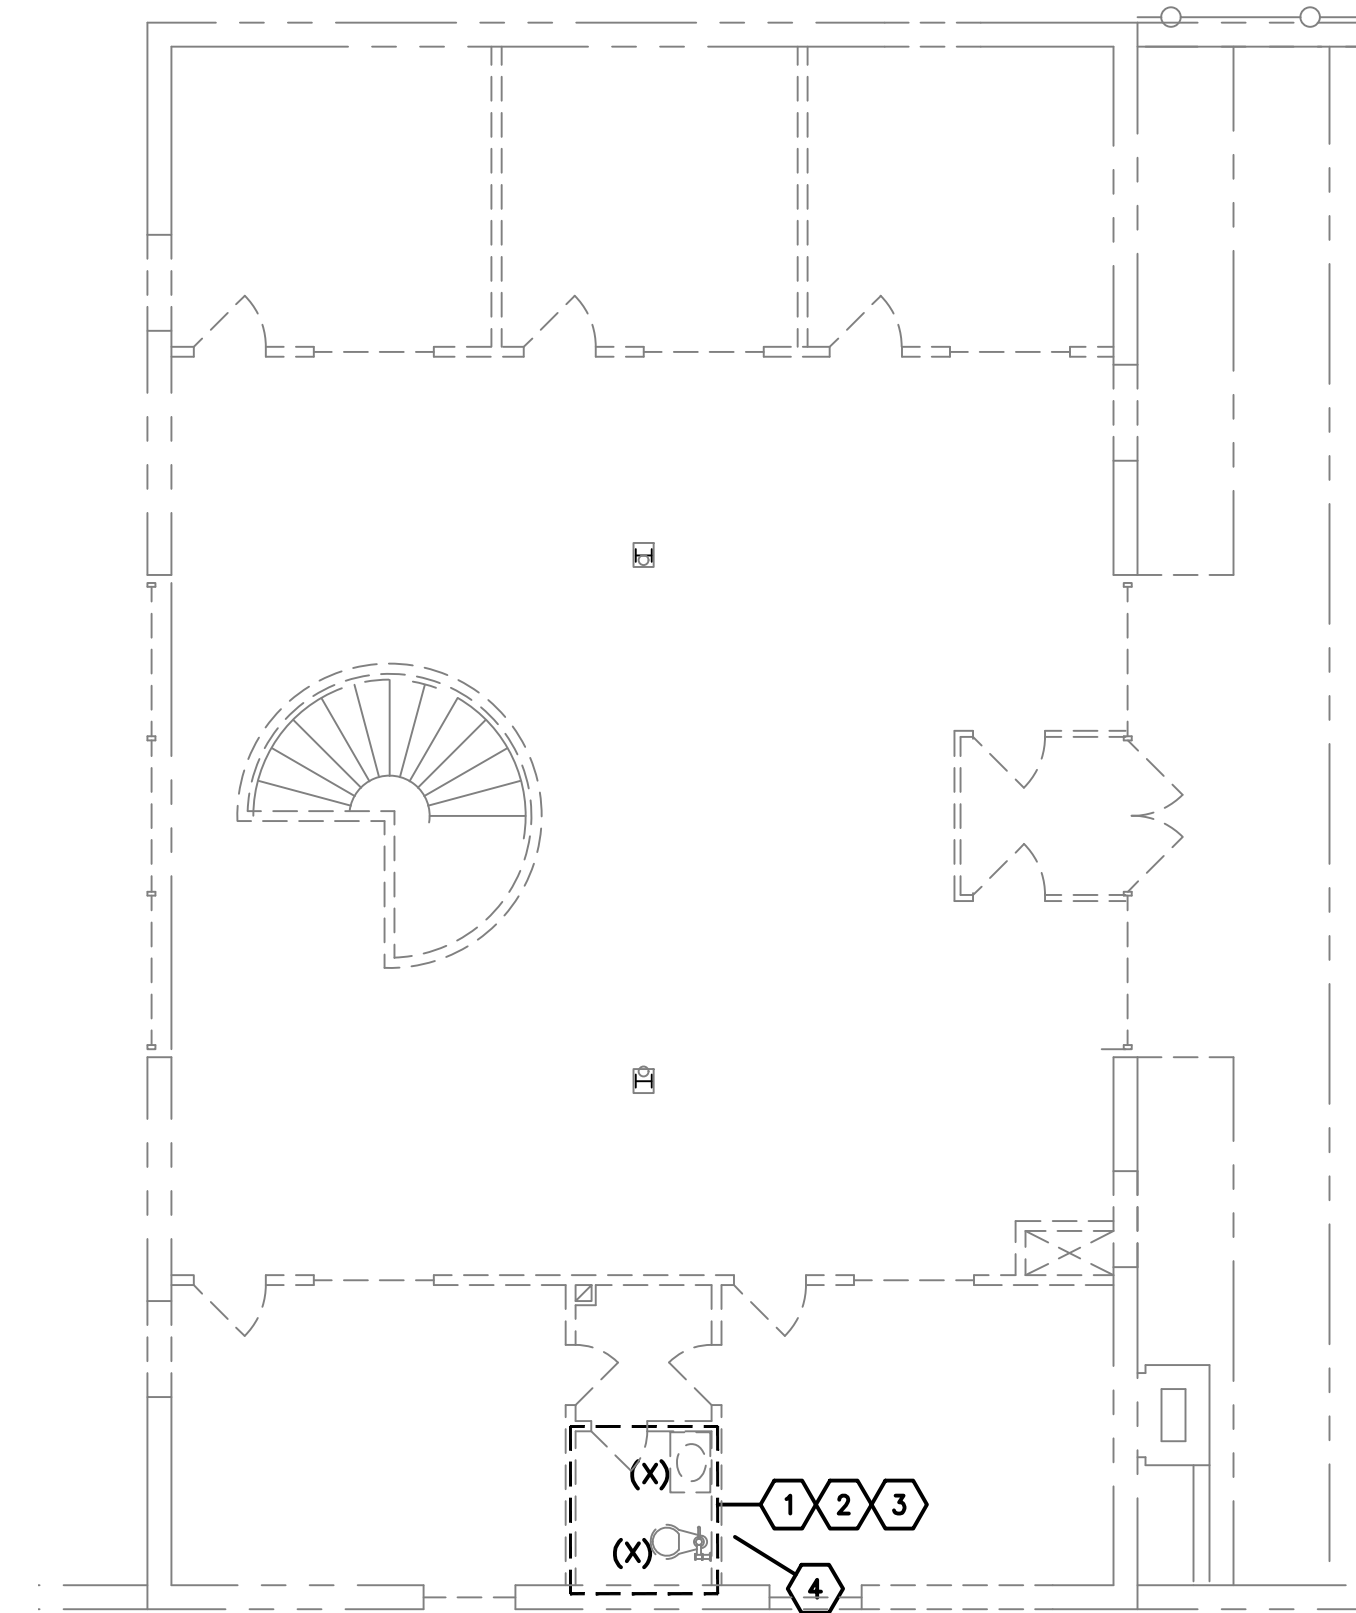

MAIN LEVEL PLUMBING DEMO FLOOR PLAN
SCALE: 1/8" = 1'-0"

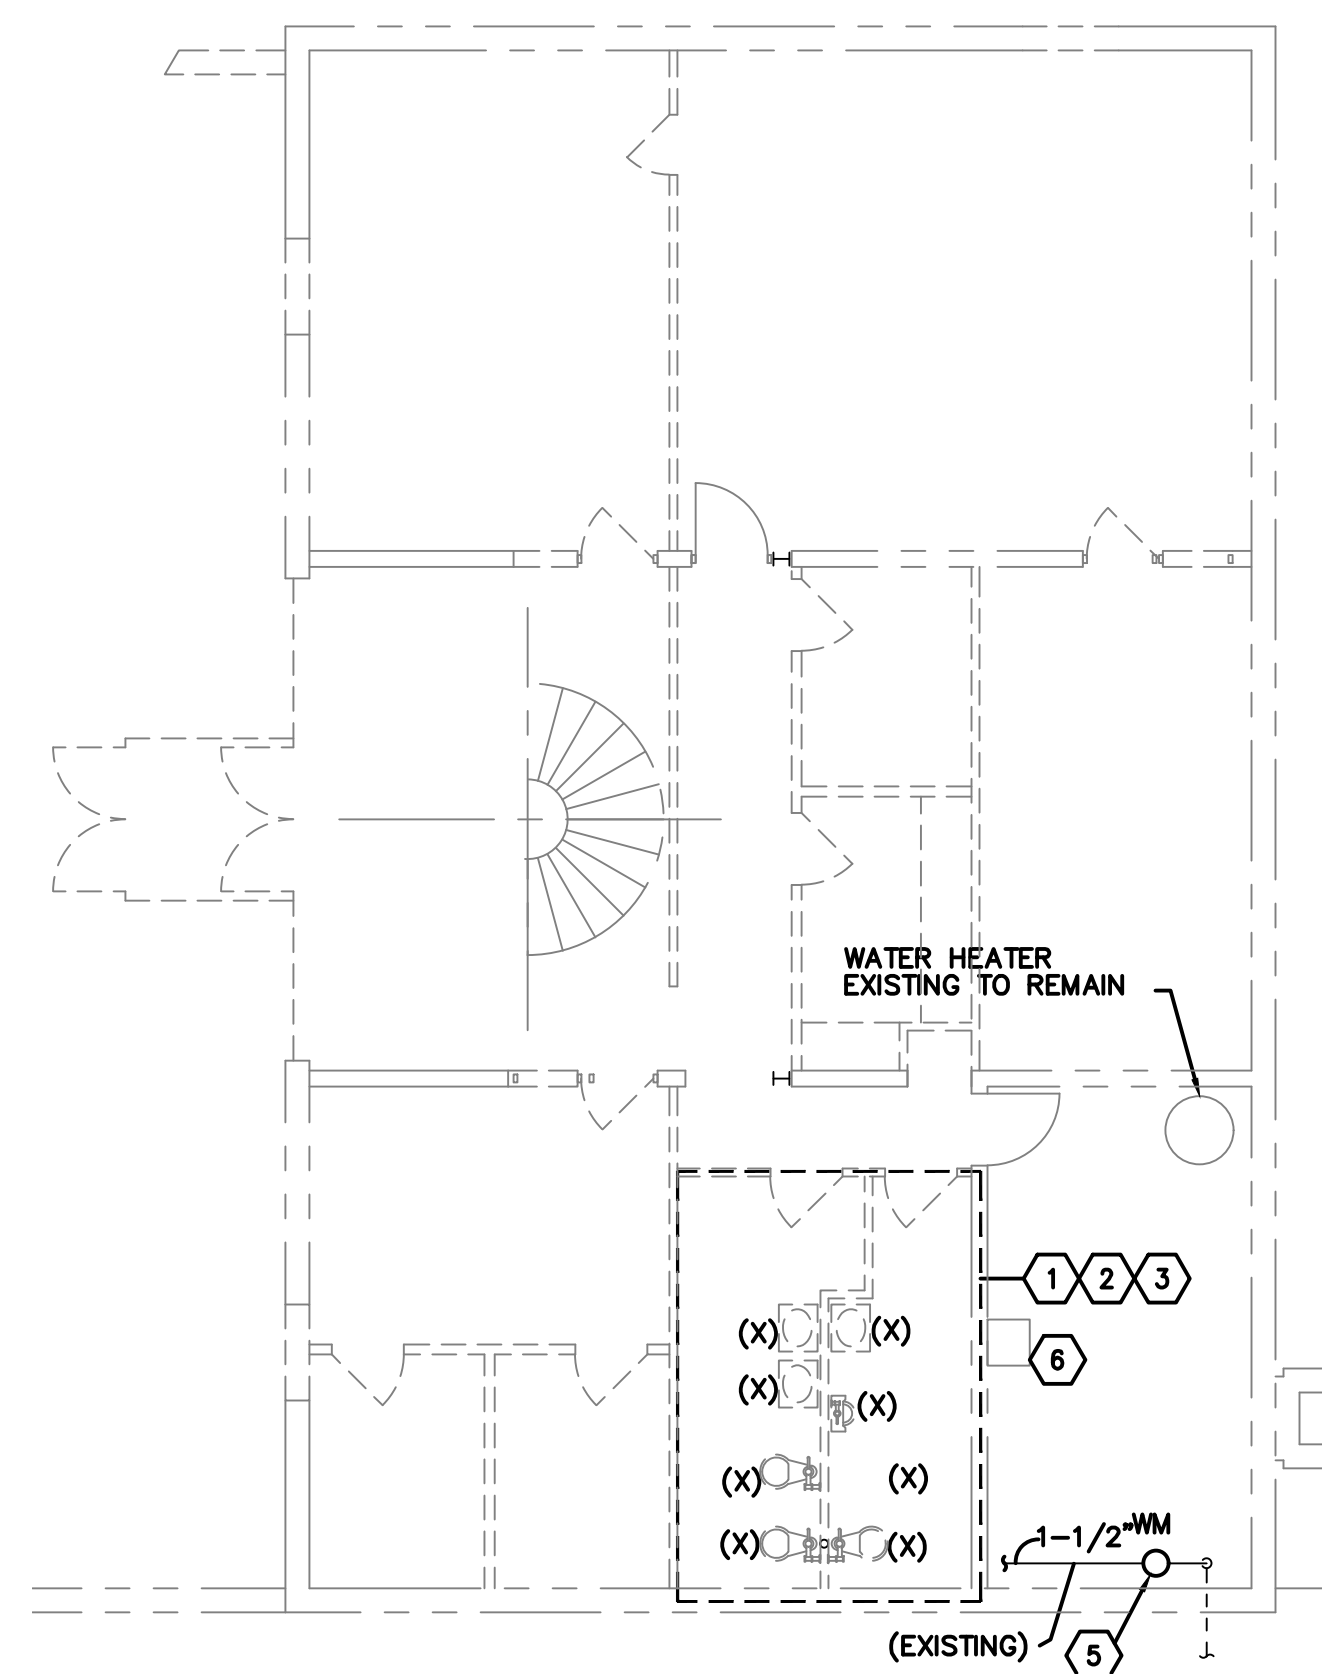

LOWER LEVEL PLUMBING DEMO FLOOR PLAN
SCALE: 1/8" = 1'-0"